
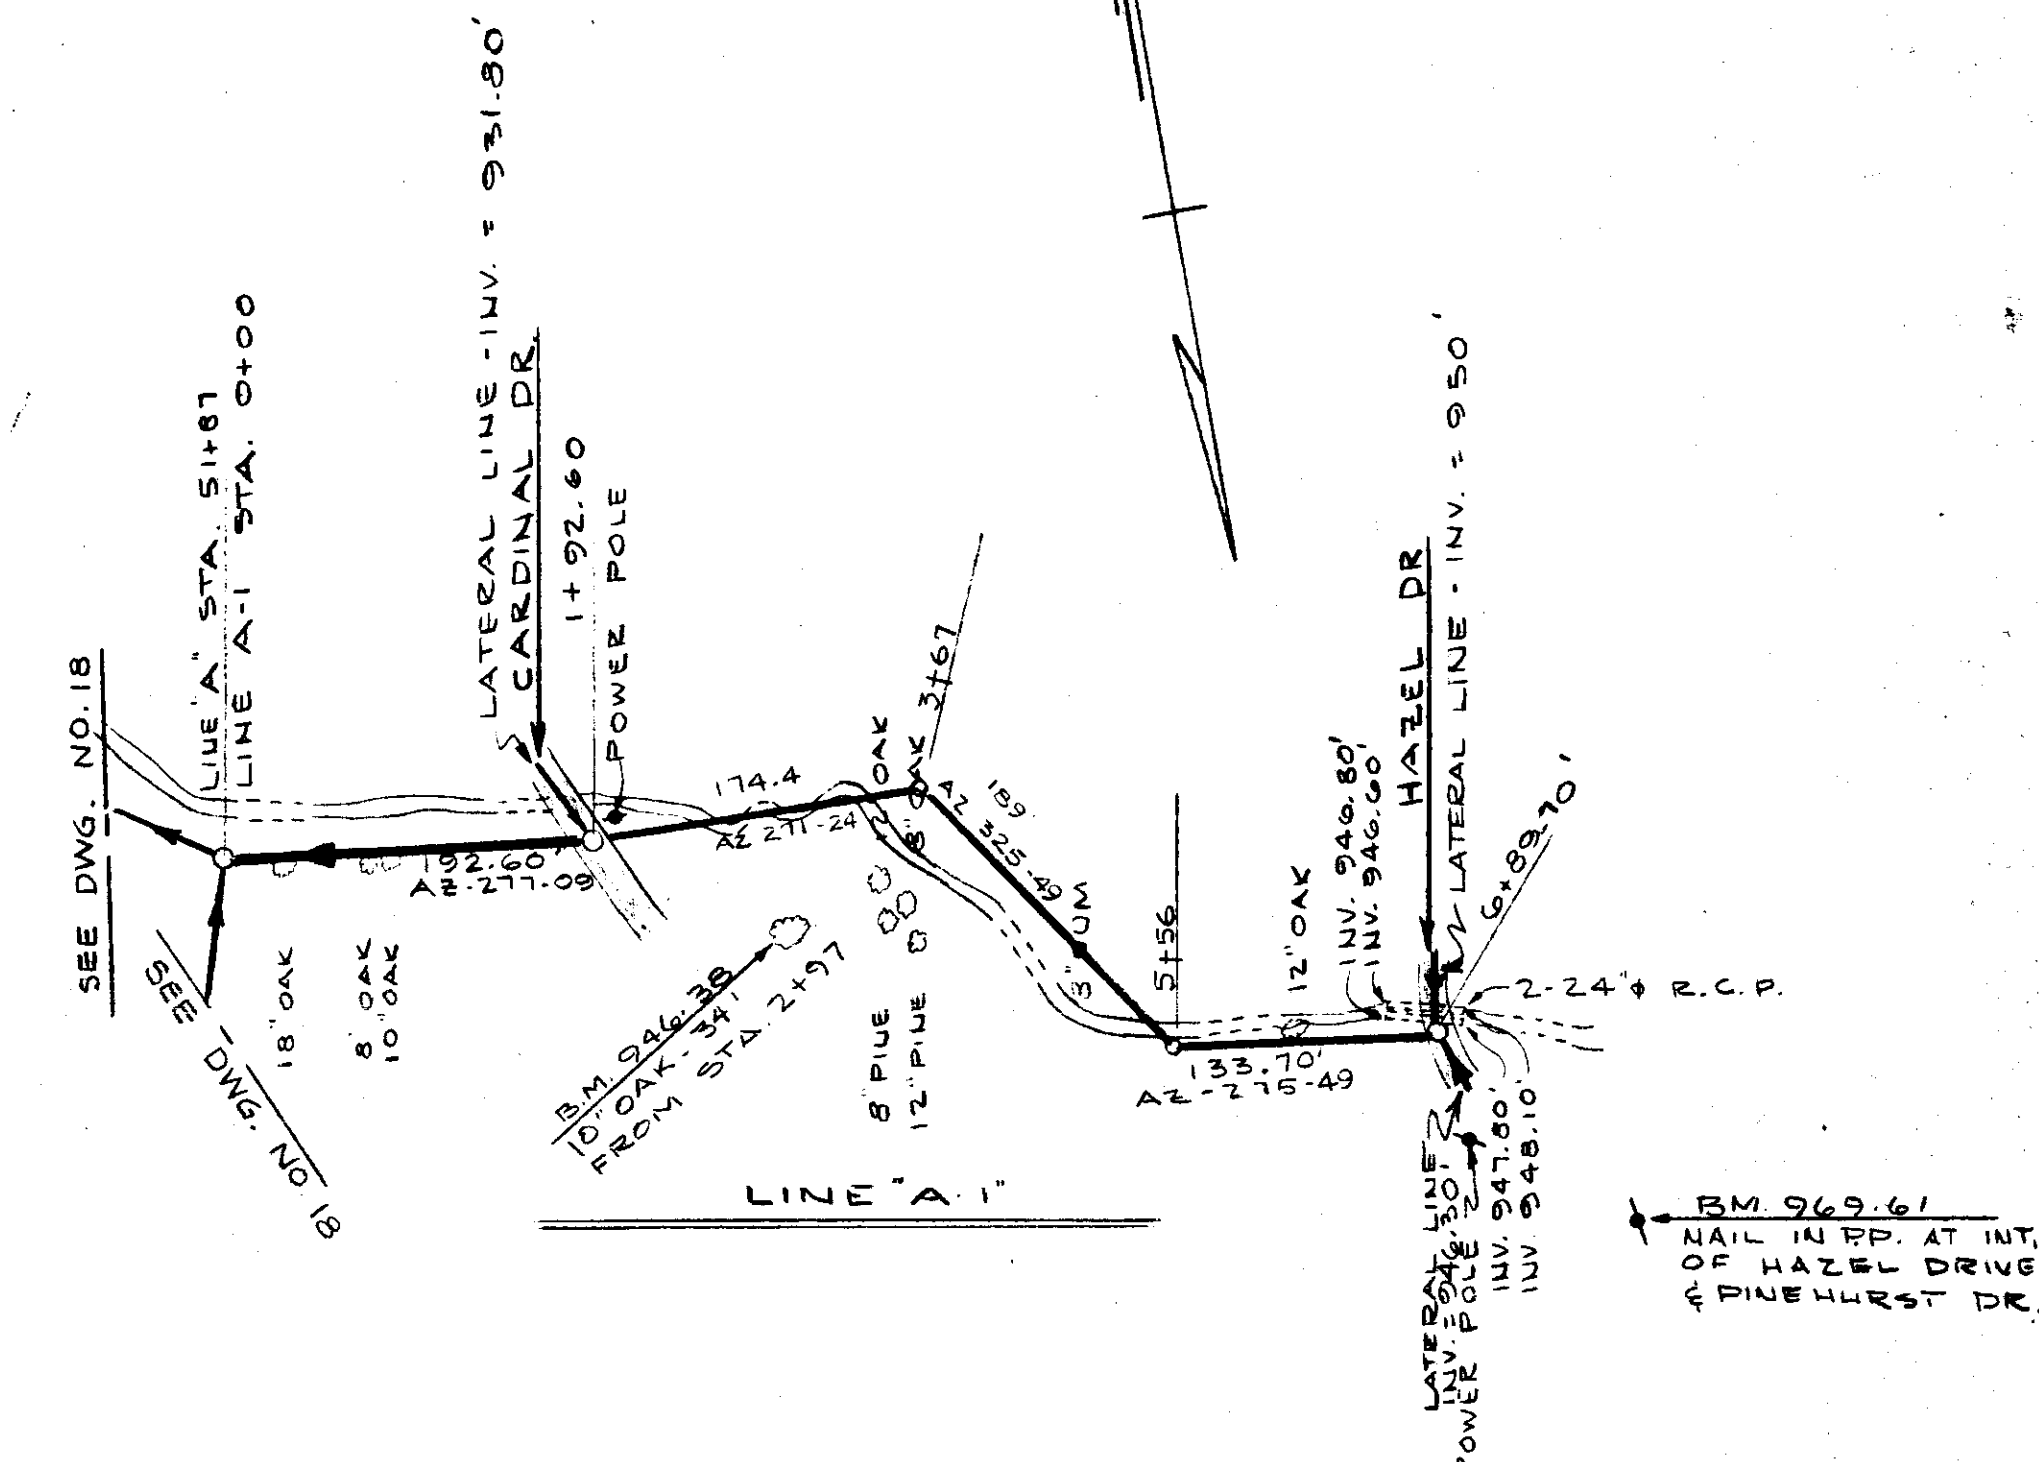


FED. ROAD DIST. No.	STATE	FEDERAL PROJ. No.	FISCAL YEAR	SHEET No.	TOTAL SHEETS

PLAN	BY	DATE
SURVEYED PLOTTED CHECKED NOTE BOOK NO.		

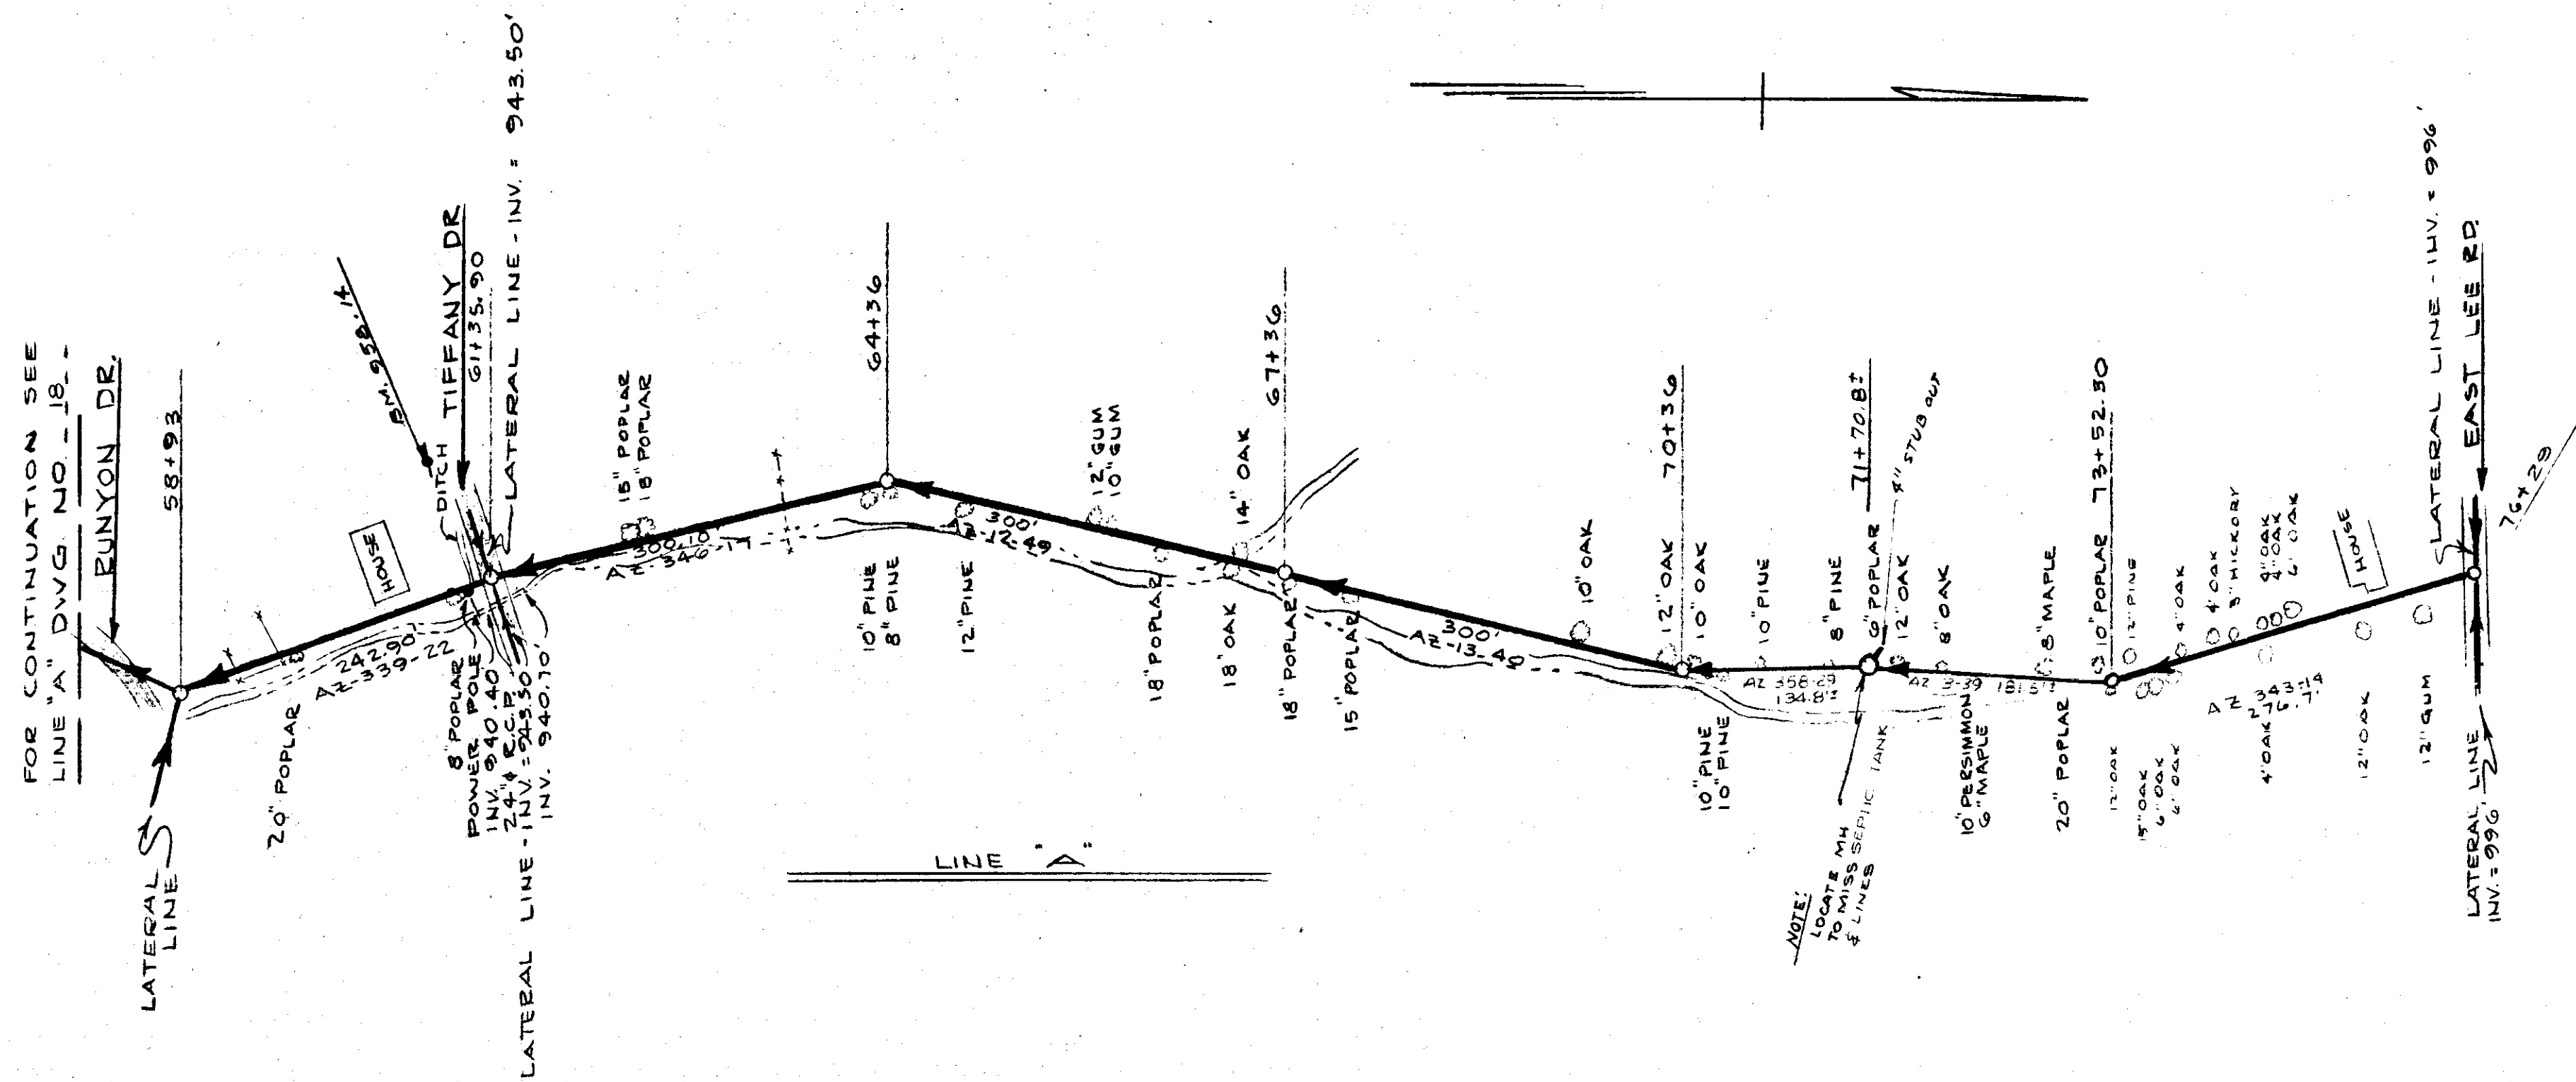


LINES A & A-1

2 1/2" IMP. P.D. REVISED LINE 70+36 - 73+52.3		DRAWN BY		DATE	
1 1/2" P.D. GENERAL		CHECKED BY		JULY 1963	
NO. DATE BY		REVISIONS		DWG. No. 19	

WADE HAMPTON WATER AND SEWER DISTRICT  
GREENVILLE COUNTY, S. C.  
**PLAN AND PROFILE  
TRUNK SYSTEM**  
PIEDMONT ENGINEERING SERVICE  
GREENVILLE, S. C.  
DRAWN BY \_\_\_\_\_ CHECKED BY \_\_\_\_\_ DATE \_\_\_\_\_

PROFILE	BY	DATE
SURVEYED PLOTTED CHECKED NOTE BOOK NO.		

SCALE  
VERT. 1" = 10'  
HORIZ. 1" = 100'

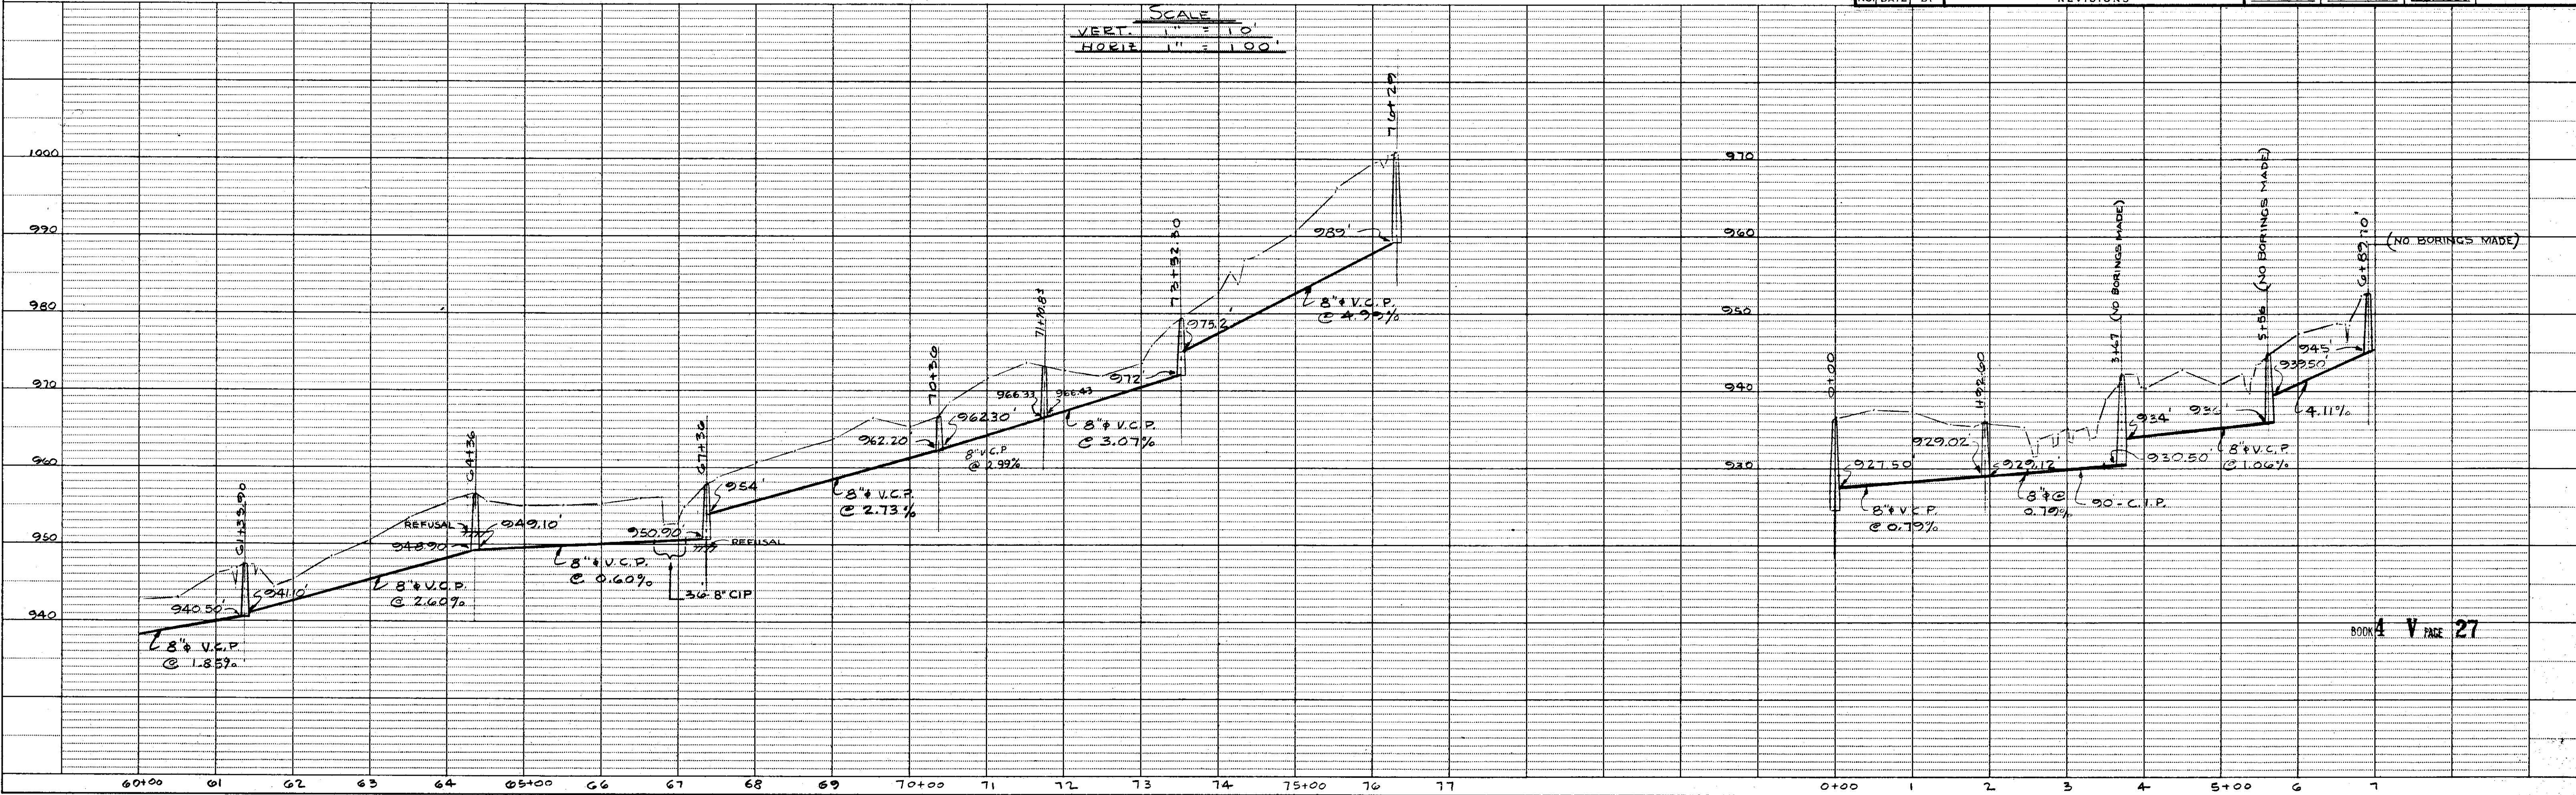

BOOK V PAGE 27