



FED. ROAD DIST. No.	STATE	FEDERAL PROJ. NO.	FISCAL YEAR	SHEET No.	TOTAL SHEETS

PLAN	DATE
SURVEYED PLOTTED ALIGNMENT CHECKED NOTE BOOK NO. _____	BY _____

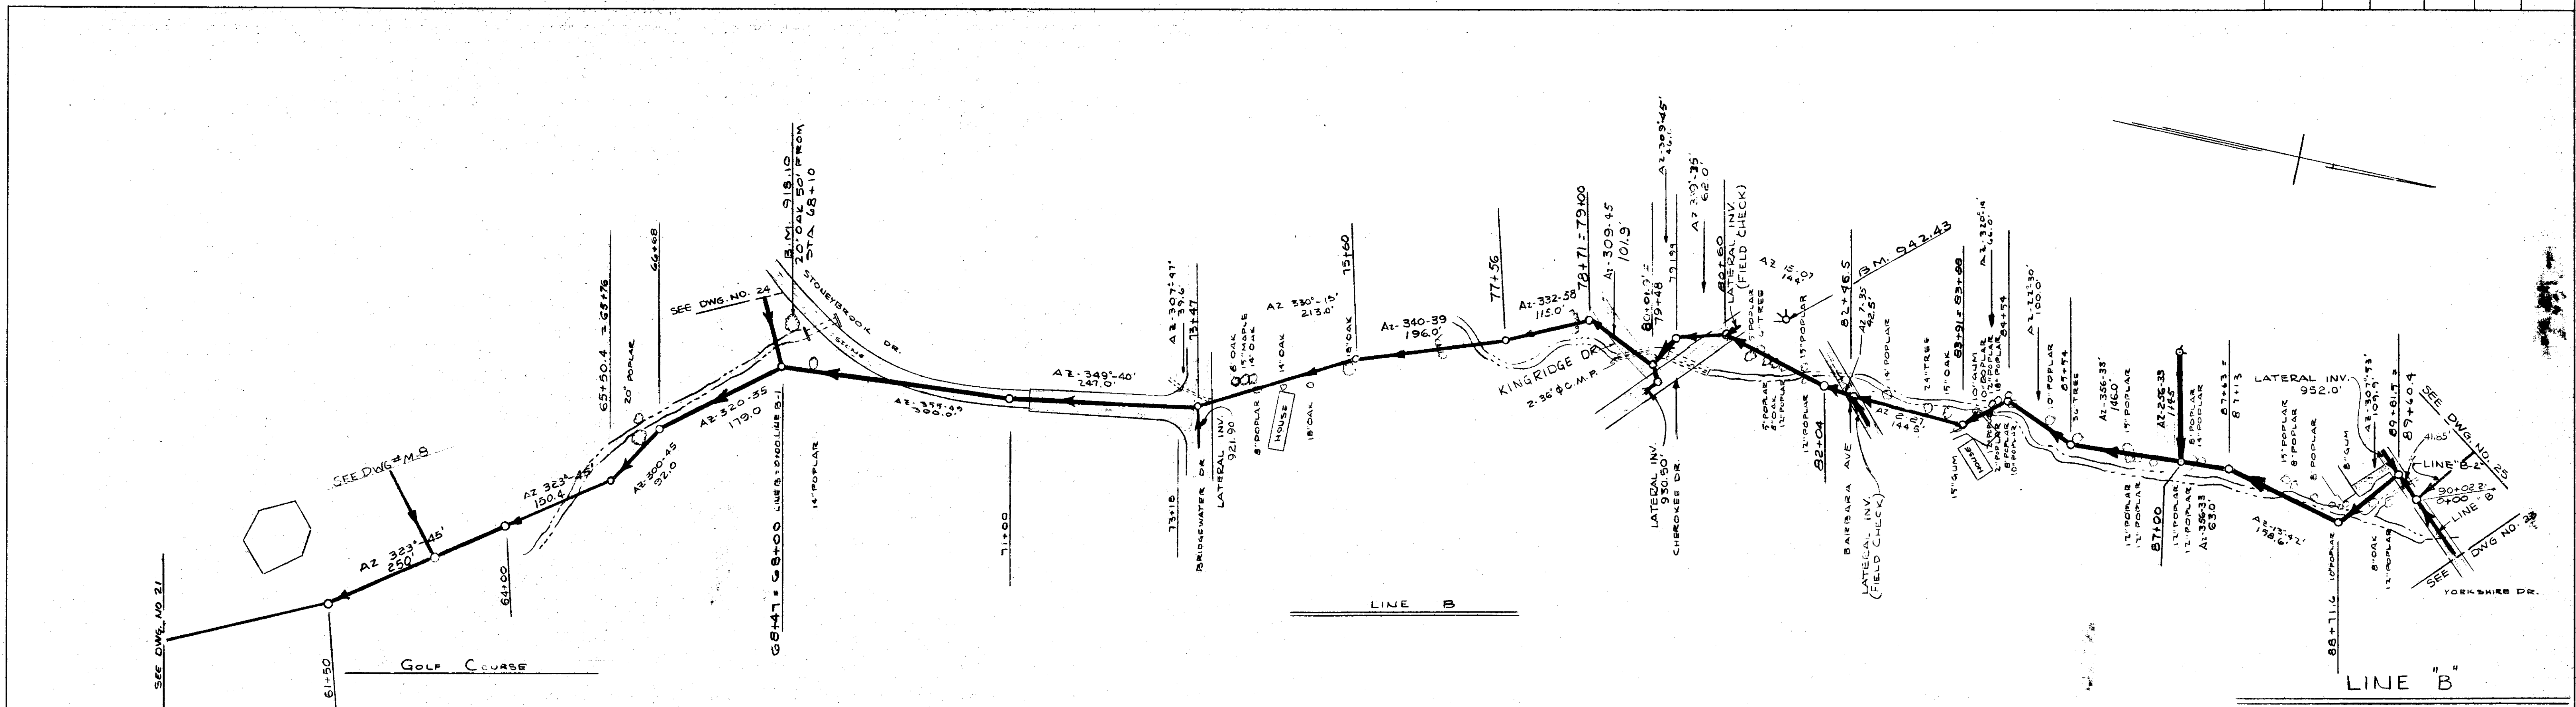

PROFILE	DATE
SURVEYED PLOTTED STRUCTURE NOTATIONS CHKD NOTE BOOK NO. _____	BY _____

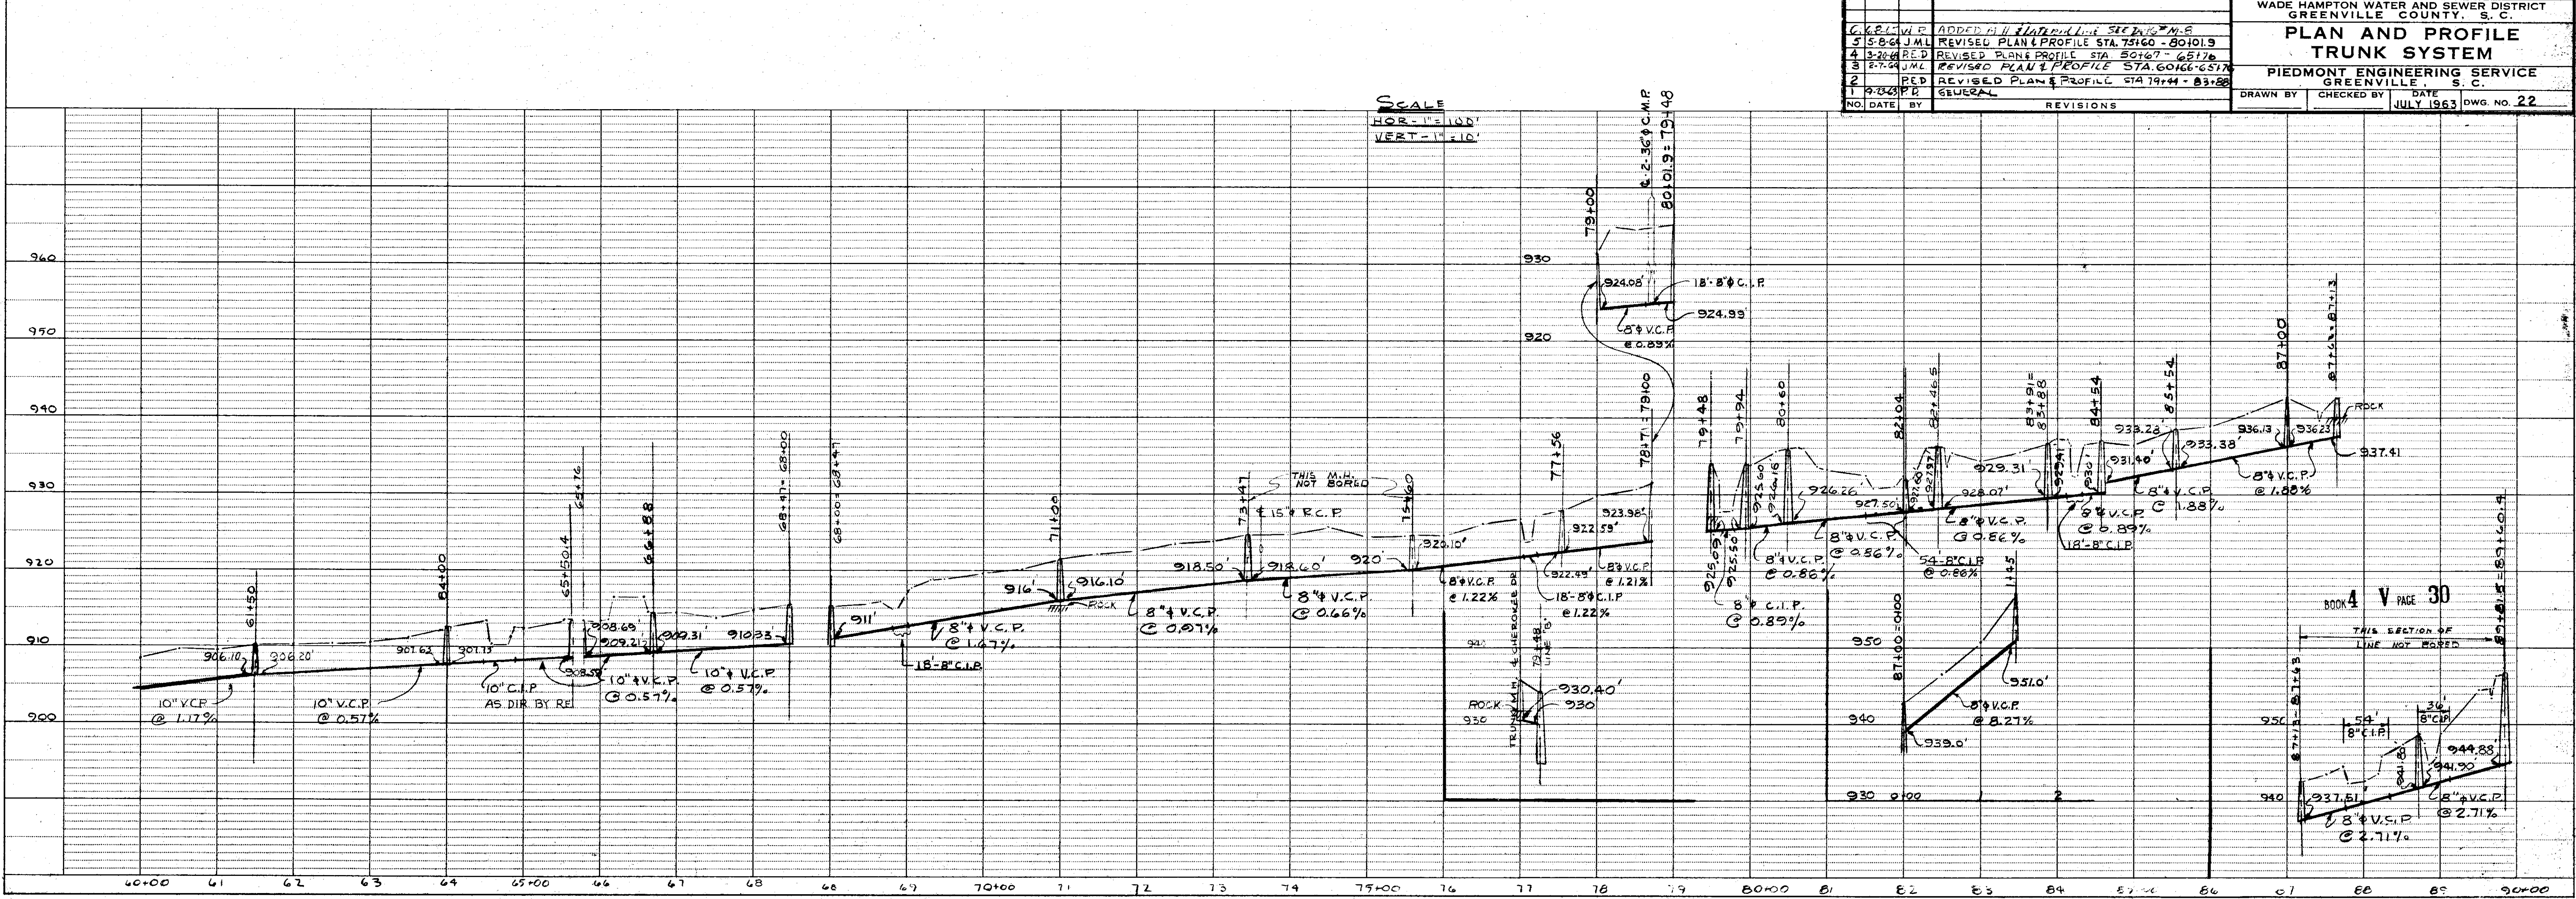

WADE HAMPTON WATER AND SEWER DISTRICT GREENVILLE COUNTY, S. C.	
<b>PLAN AND PROFILE TRUNK SYSTEM</b>	
PIEDMONT ENGINEERING SERVICE GREENVILLE, S. C.	
NO. DATE BY	REVISIONS
1 7-13-63 J.M.C.	REVISED PLAN & PROFILE STA 79+44 - 83+88
2 8-1-63 J.M.C.	REVISED PLAN & PROFILE STA 60+66 - 65+74
3 8-27-63 J.M.C.	REVISED PLAN & PROFILE STA 50+67 - 65+74
4 3-26-64 J.M.C.	REVISED PLAN & PROFILE STA 50+67 - 80+01.9
5 5-8-64 J.M.C.	REVISED PLAN & PROFILE STA 75+60 - 80+01.9
6 8-1-64 J.M.C.	REVISED PLAN & PROFILE STA 60+66 - 65+74
7 8-1-64 J.M.C.	REVISED PLAN & PROFILE STA 79+44 - 83+88
DRAWN BY _____ CHECKED BY _____ DATE _____	
DWG. NO. 22	

SINGLE PLAN AND PROFILE - DOTTED  
H. A. ROGERS CO. - MINNEAPOLIS - ST. PAUL - DULUTH