

PLAN

BY _____ DATE _____

REVISIONS


NO. DATE BY

1. 7/13/63 BY GENERAL

NOTE BOOK NO. _____

ALIGNMENT CHECKED

RT. OF WAY CHECKED

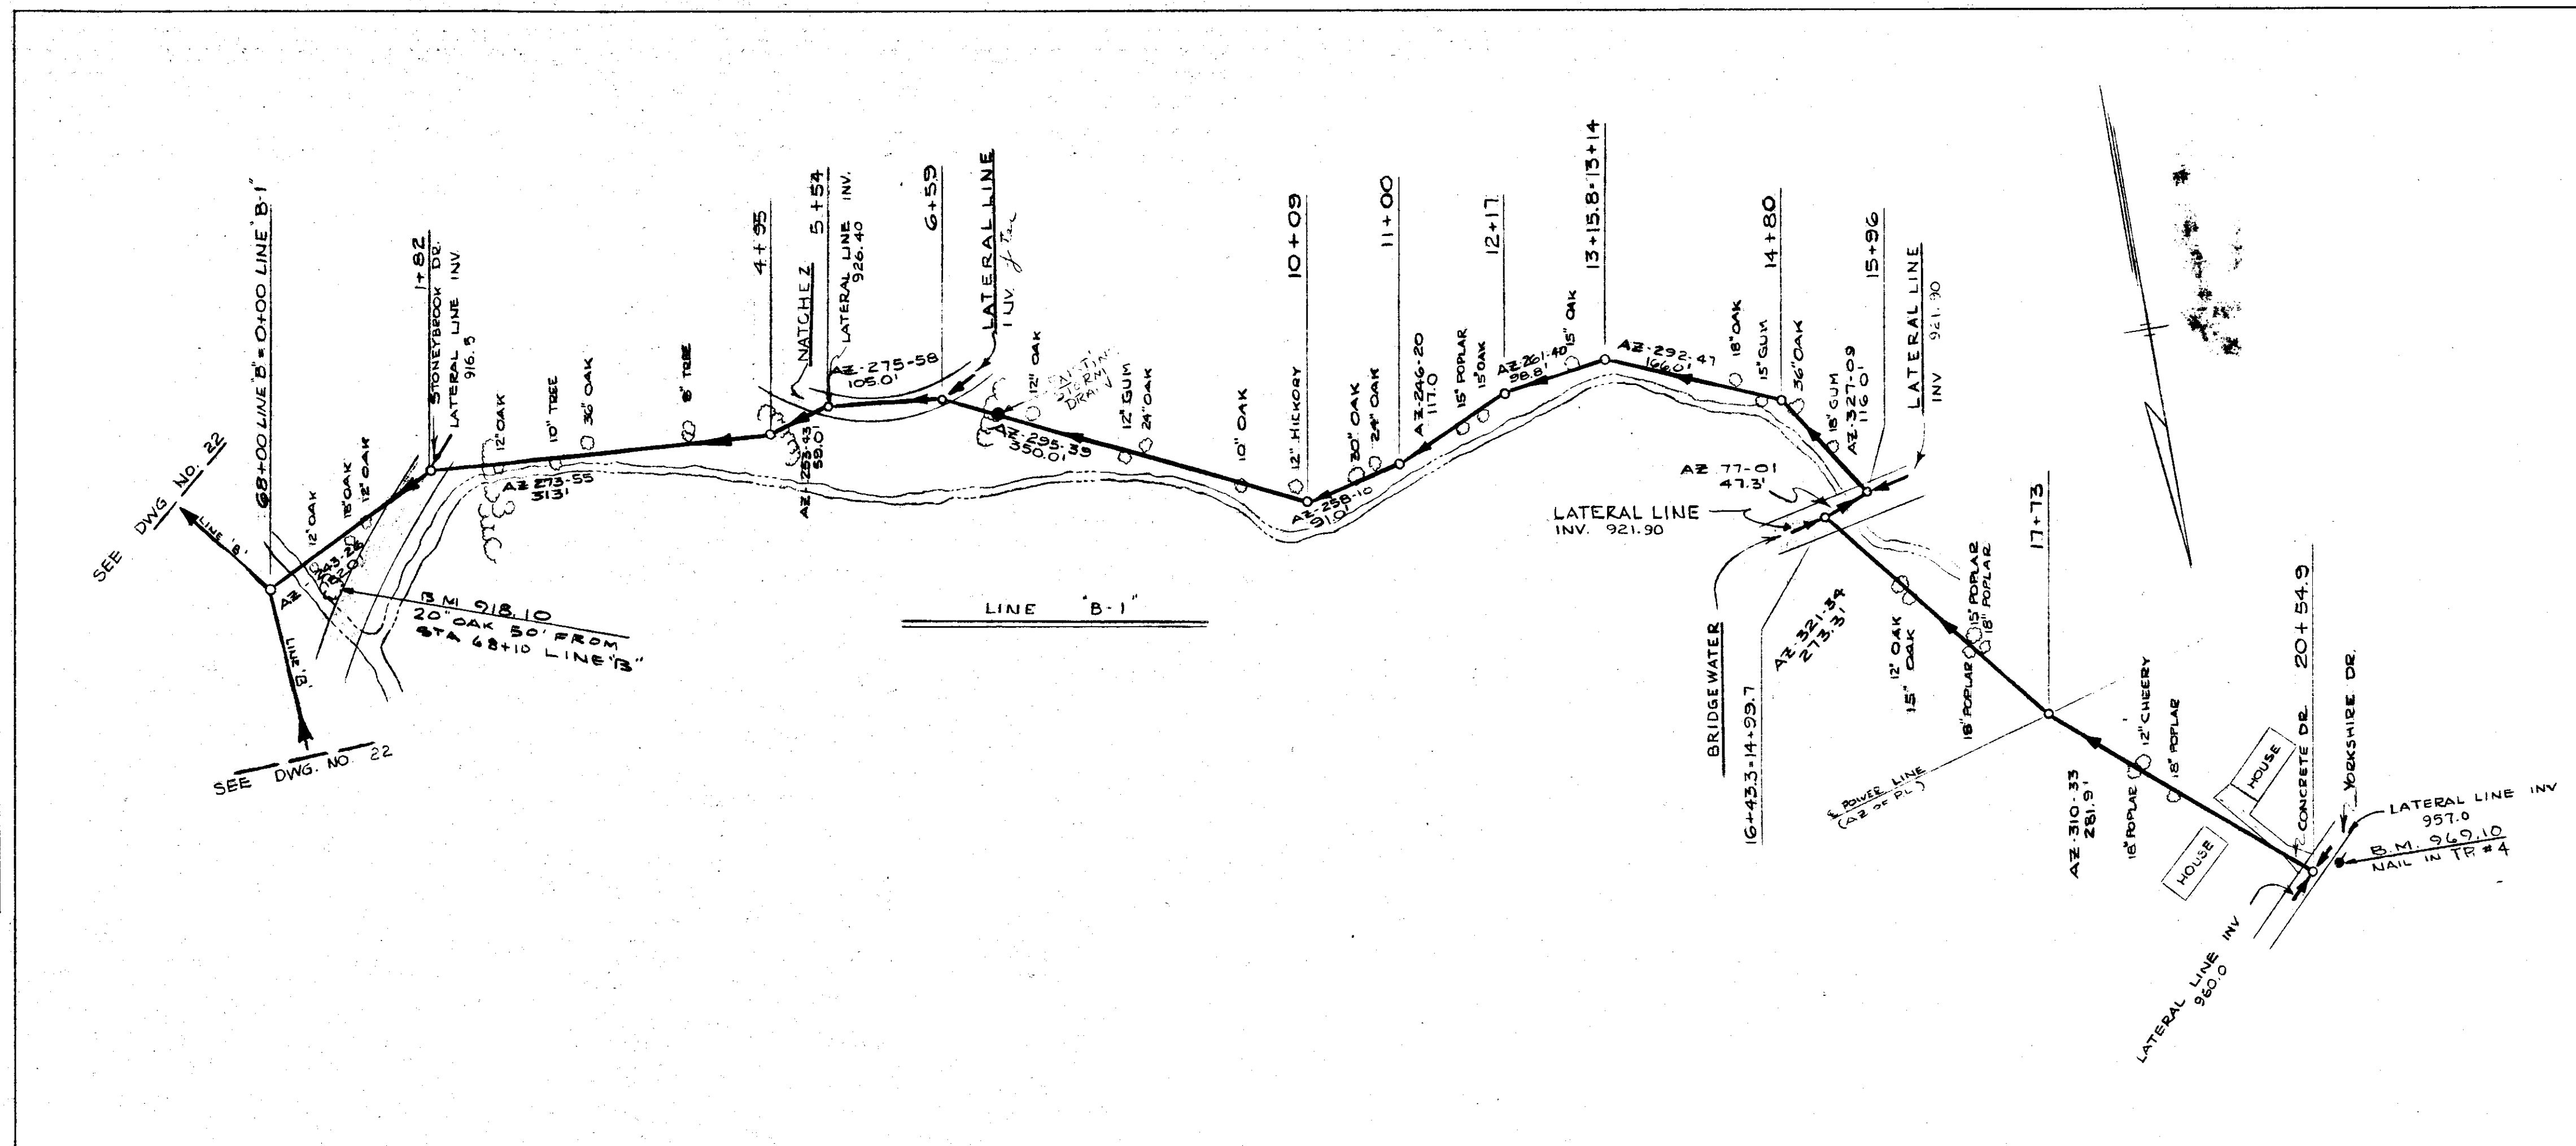

LINE "B-1"

WADE HAMPTON WATER AND SEWER DISTRICT
GREENVILLE COUNTY, S. C.

**PLAN AND PROFILE
TRUNK SYSTEM**

PIEDMONT ENGINEERING SERVICE
GREENVILLE, S. C.

NO.	DATE	BY	REVISIONS
1	7/13/63	BY	GENERAL

DRAWN BY _____ CHECKED BY _____ DATE _____

JULY 1963 DWG. NO. 24

PROFILE

BY _____ DATE _____

REVISIONS

NO. DATE BY

1. 7/13/63 BY GENERAL

NOTE BOOK NO. _____

GRADES CHECKED

STRUCTURE NOTATIONS CHECKED

