



PLAN	DATE
SURVEYED	
ALIGNED	
CHECKED	
BY	
NOTE BOOK NO.	
NO.	

PROFILE	DATE
SURVEYED	
GRADES CHECKED	
BY	
NOTE BOOK NO.	
NO.	

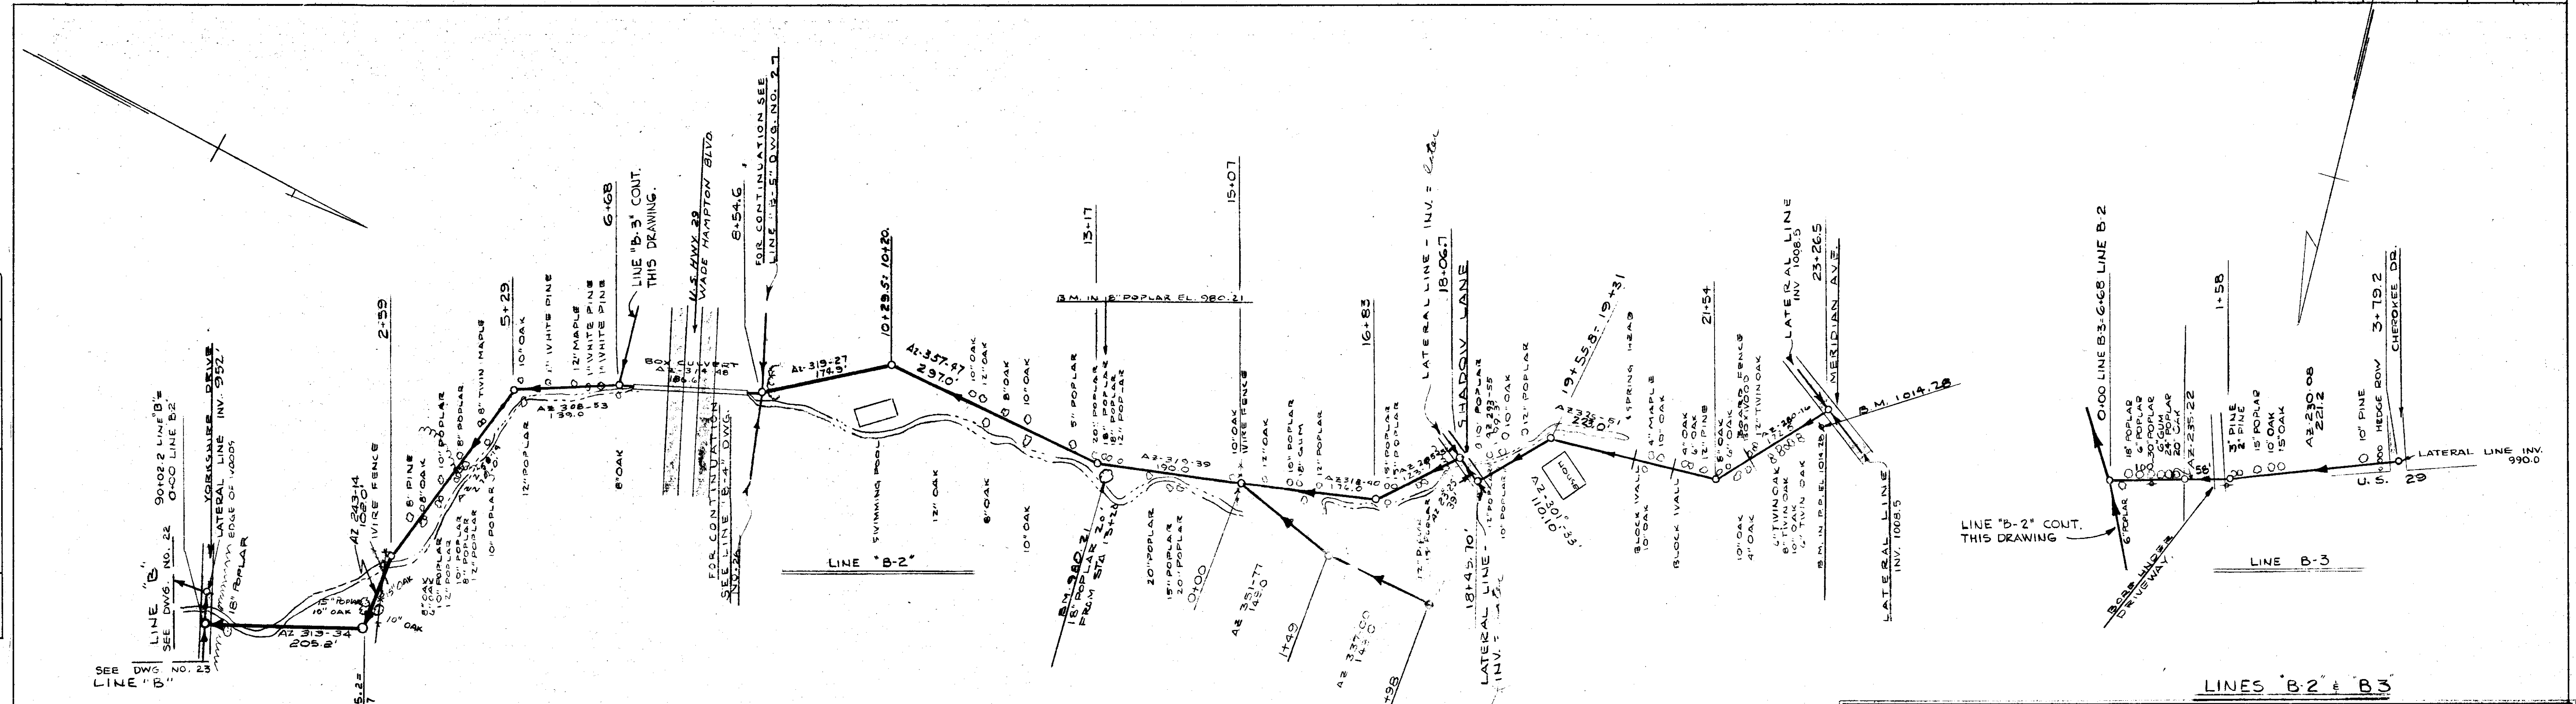

WADE HAMPTON WATER AND SEWER DISTRICT GREENVILLE COUNTY, S. C.	
PLAN AND PROFILE TRUNK SYSTEM	
PIEDMONT ENGINEERING SERVICE GREENVILLE, S. C.	
DRAWN BY	CHECKED BY
DATE	DATE
JULY 1963 DWG. NO. 25	

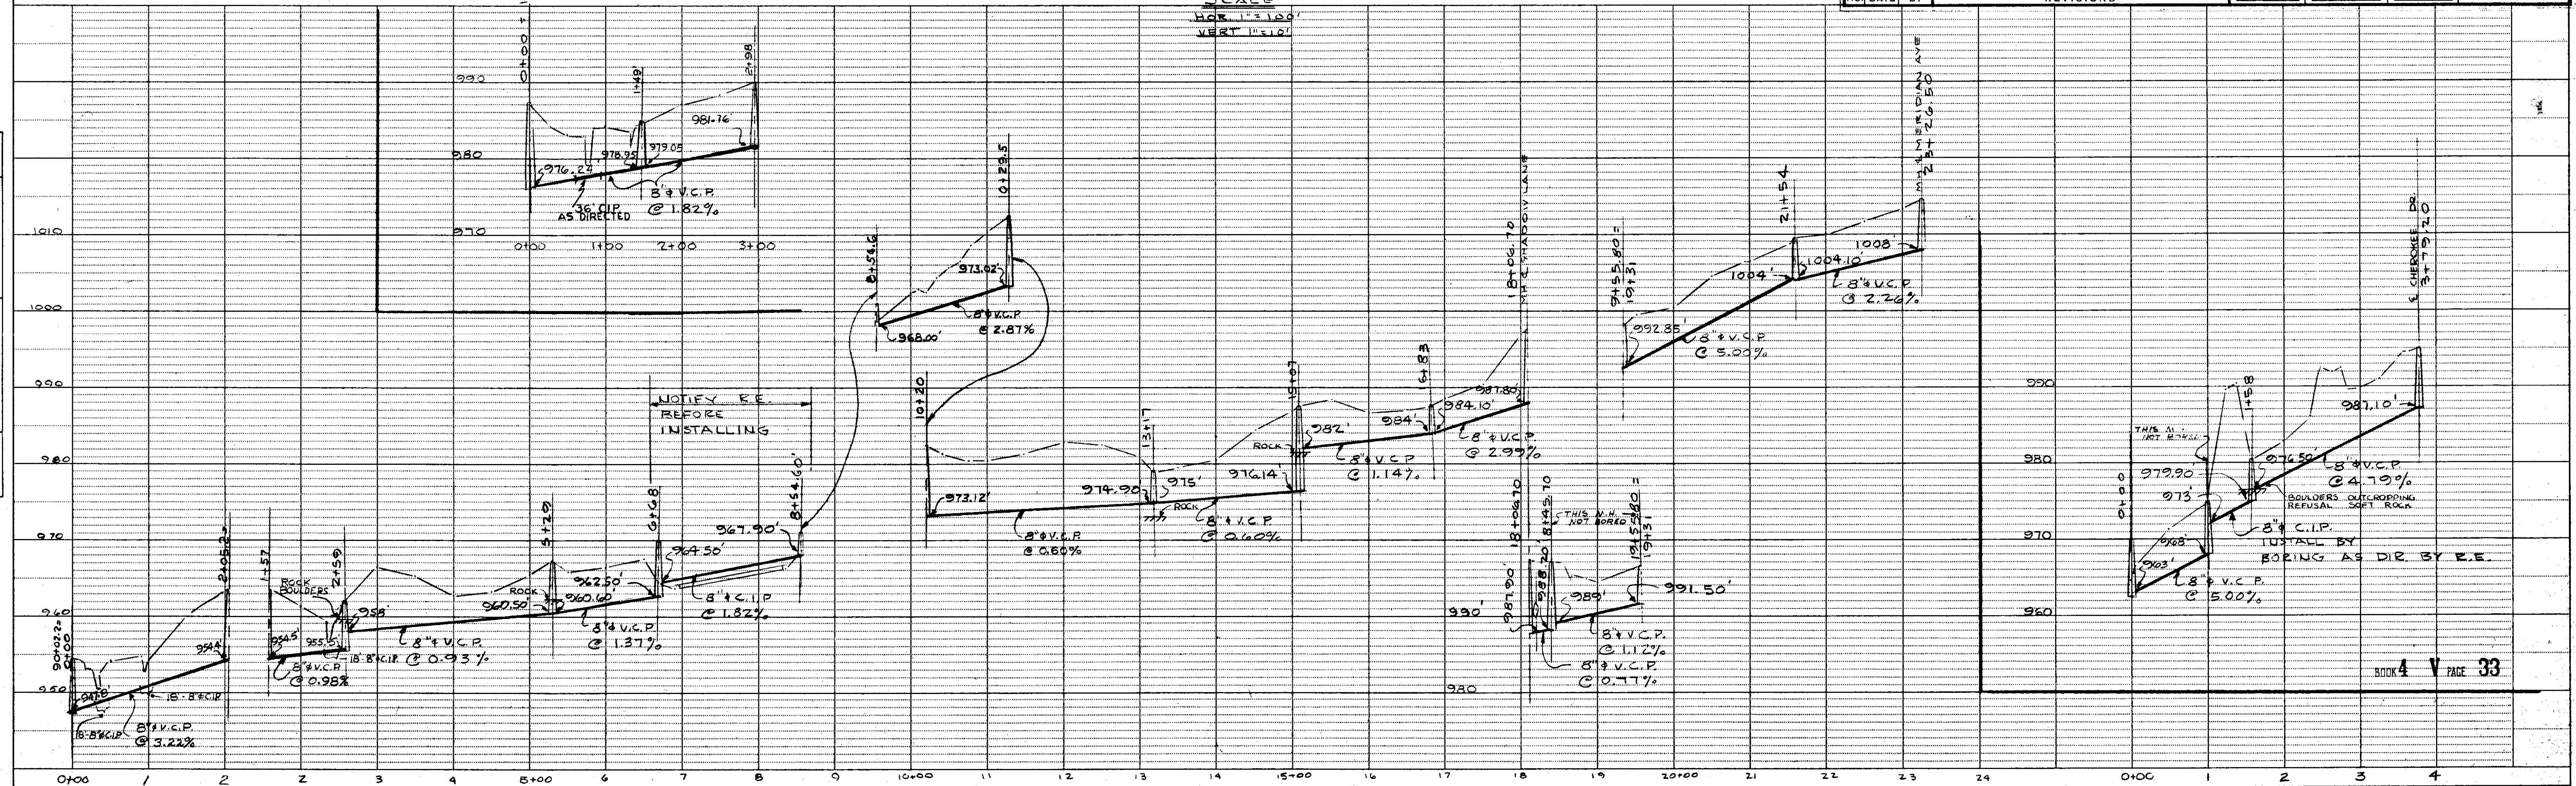

SINGLE PLAN AND PROFILE - DOTTED
H. A. ROGERS CO., MINNEAPOLIS - ST. PAUL - DULUTH