


FED. ROAD DIST. No.	STATE	FEDERAL PROJ. NO.	FISCAL YEAR	SHEET No.	TOTAL SHEETS
---------------------	-------	-------------------	-------------	-----------	--------------

PLAN

BY	DATE
SURVEYED	
ALIGNMENT CHECKED	
RT. OF WAY CHECKED	
NOTE BOOK NO.	

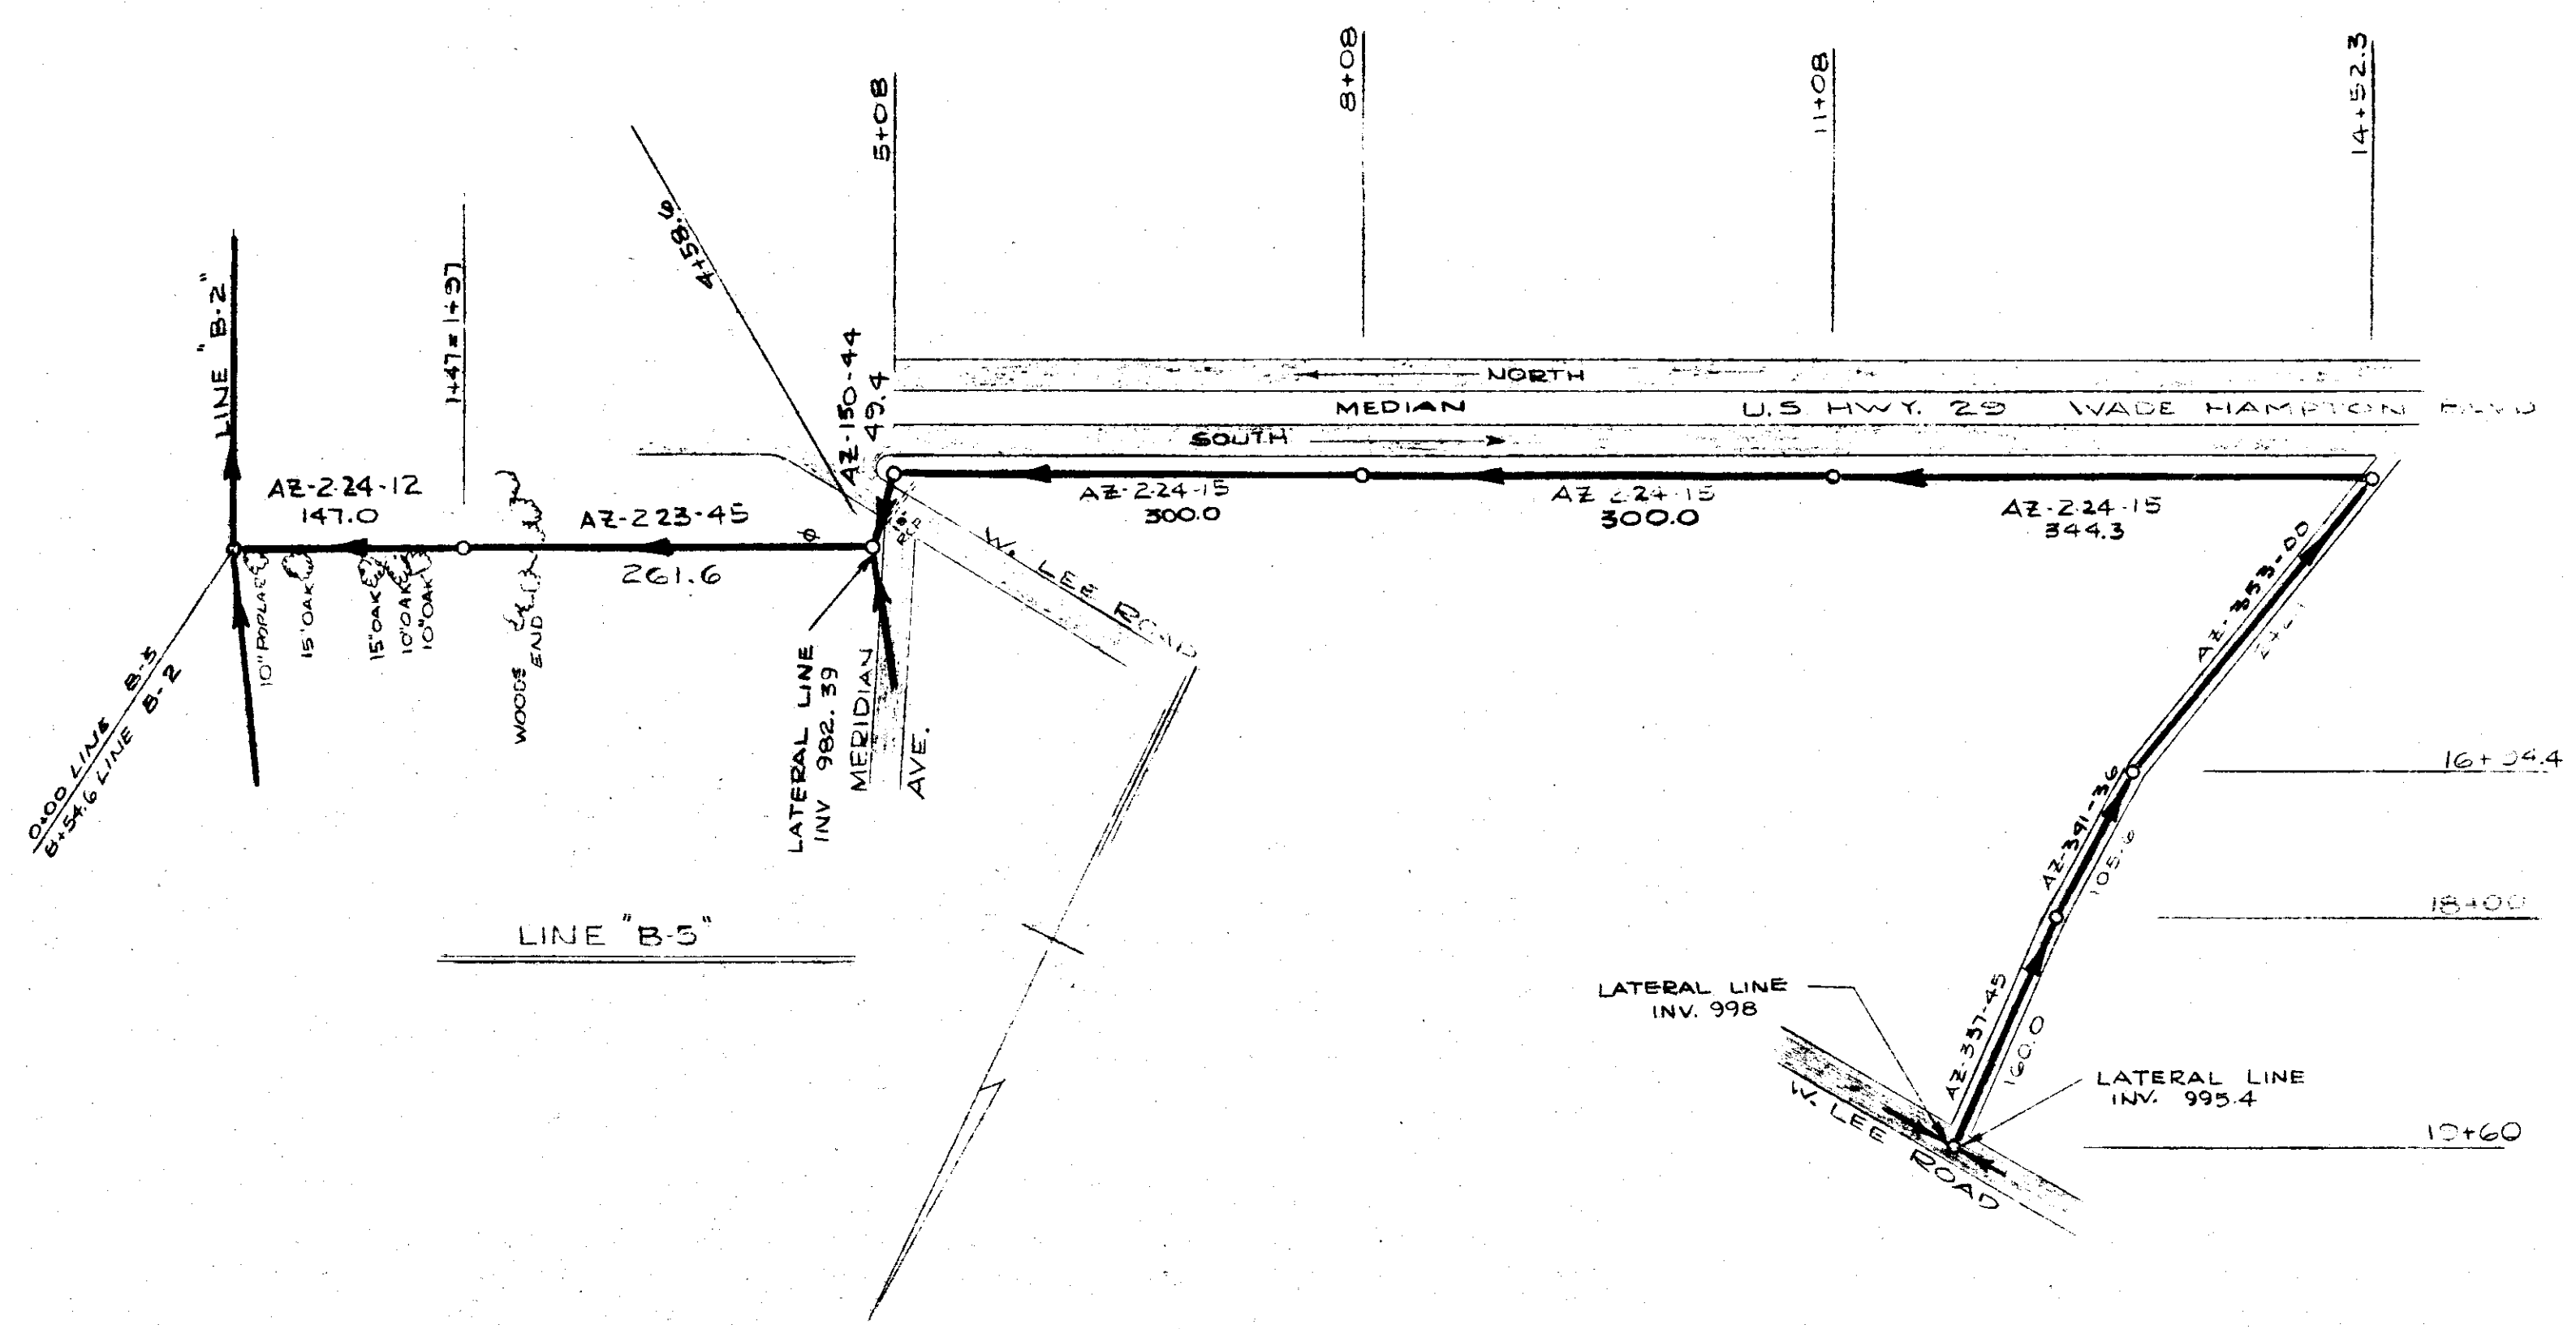

1 9343 PD		GENERAL	REVISIONS
NO.	DATE	BY	

WADE HAMPTON WATER AND SEWER DISTRICT
 GREENVILLE COUNTY, S. C.
PLAN AND PROFILE
TRUNK SYSTEM
 PIEDMONT ENGINEERING SERVICE
 GREENVILLE, S. C.
 DRAWN BY: _____ CHECKED BY: _____ DATE: JULY 1963 DWG. No. 27

PROFILE

BY	DATE
SURVEYED	
GRADES CHECKED	
B.M.'S NOTED	
STRUCTURE NOTATIONS CHECKED	
NOTE BOOK NO.	

