



FED. ROAD DIST. No.	STATE	FEDERAL PROJ. NO.	FISCAL YEAR	SHEET No.	TOTAL SHEETS
---------------------	-------	-------------------	-------------	-----------	--------------

PLAN	SURVEYED	DATE
	PLOTTED	
	BY	
	NOTE BOOK NO.	
	BY WHOM CHECKED	
	DATE	

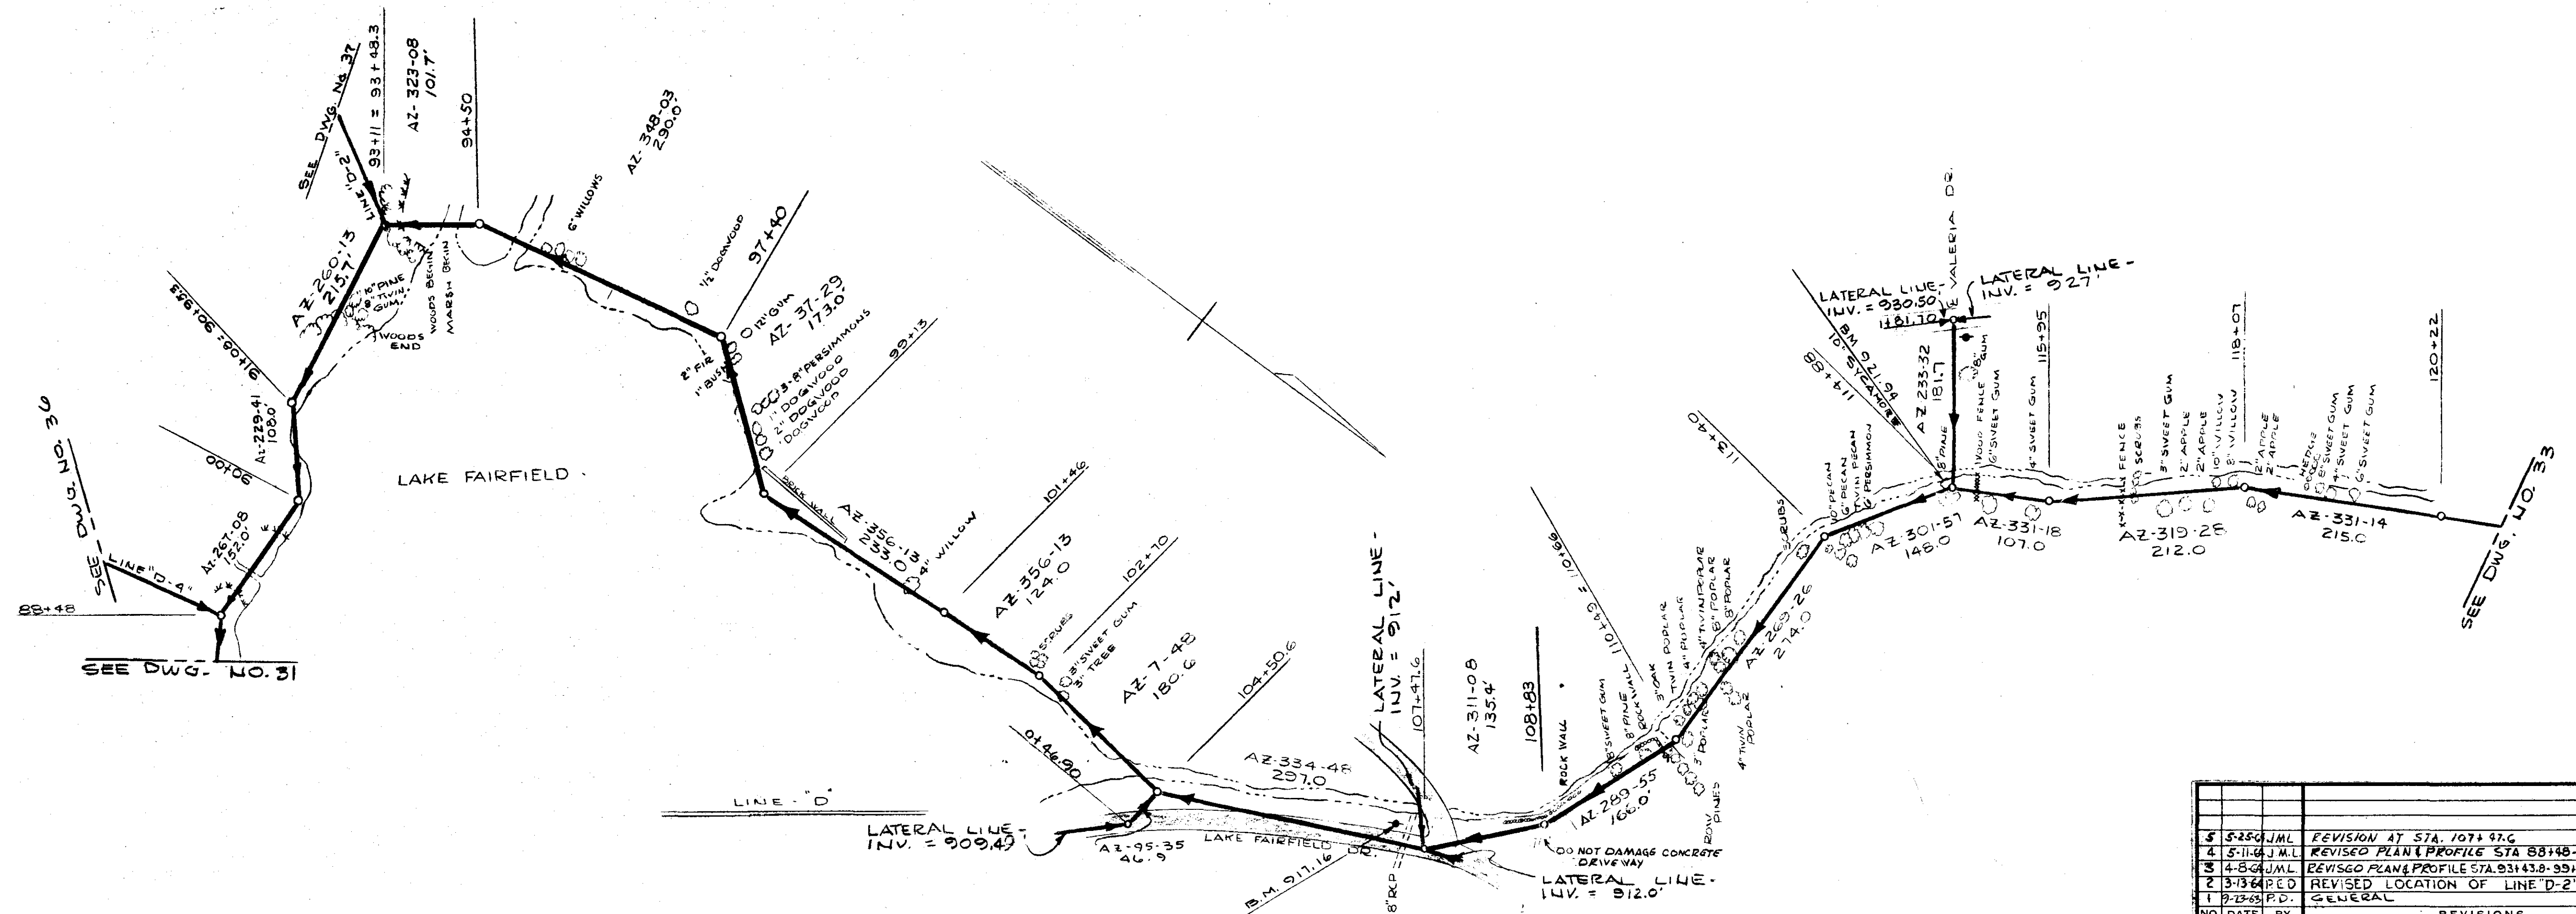

5-25-64 JML REVISION AT STA. 107+97.6		WADE HAMPTON WATER AND SEWER DISTRICT GREENVILLE COUNTY, S. C. PLAN AND PROFILE TRUNK SYSTEM PIEDMONT ENGINEERING SERVICE GREENVILLE, S. C. DRAWN BY _____ CHECKED BY _____ DATE JULY 1963 DWG. NO. 32
4-5-64 JML REVISION PLAN & PROFILE STA 88+48-91+08		
3-4-64 JML REVISION PLAN & PROFILE STA 93+43.8-95+13 1007+17.6		
2-3-64 RED REVISION LOCATION OF LINE "D-2" 107+88		
1-9-63 P.D. GENERAL		

PROFILE	SURVEYED	DATE
	PLOTTED	
	BY	
	NOTE BOOK NO.	
	BY WHOM CHECKED	
	DATE	

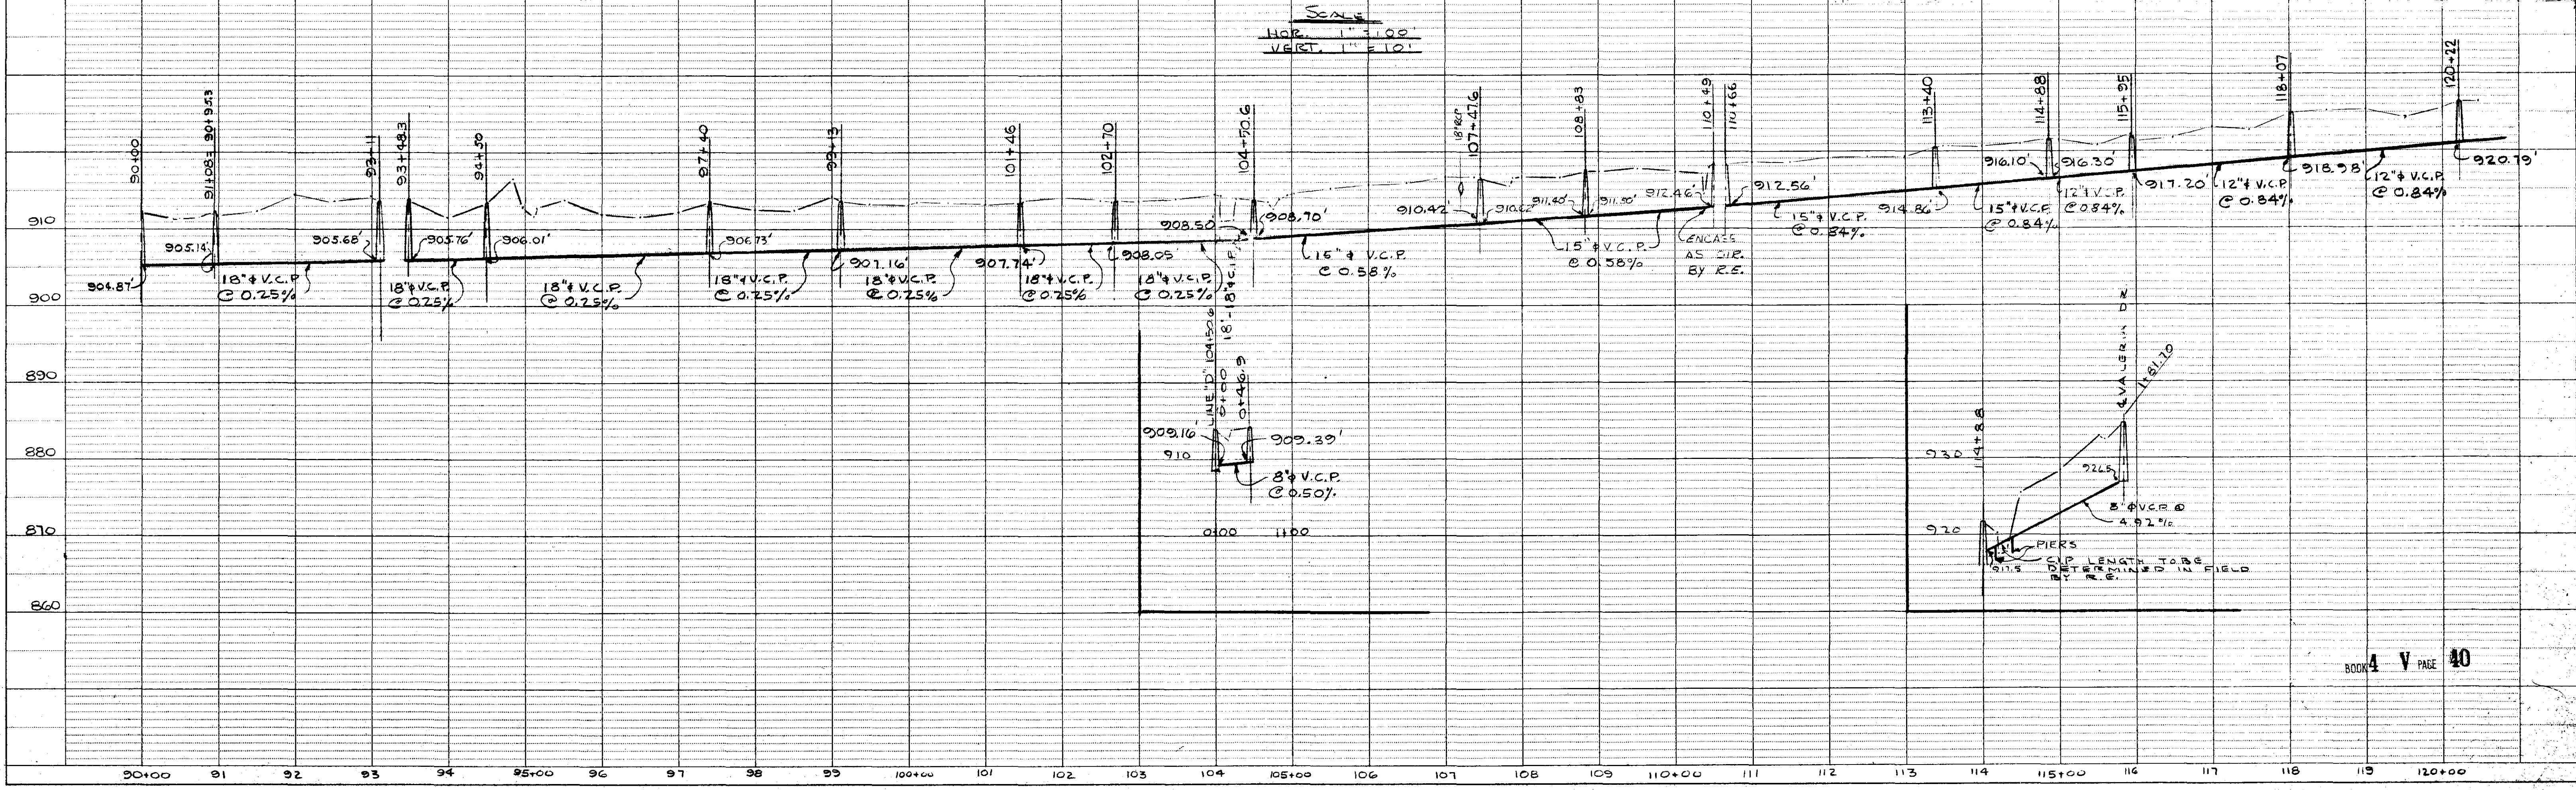

SINGLE PLAN AND PROFILE - DOTTED
 H. A. ROGERS CO. - MINNEAPOLIS - ST. PAUL - DULUTH