



PLAN	SURVEYED	BY	DATE
	PLOTTED		
NOTE BOOK NO.	ALIGNMENT CHECKED		
	BY		

PROFILE	SURVEYED	BY	DATE
	PLOTTED		
NOTE BOOK NO.	GRADES CHECKED		
	BY		

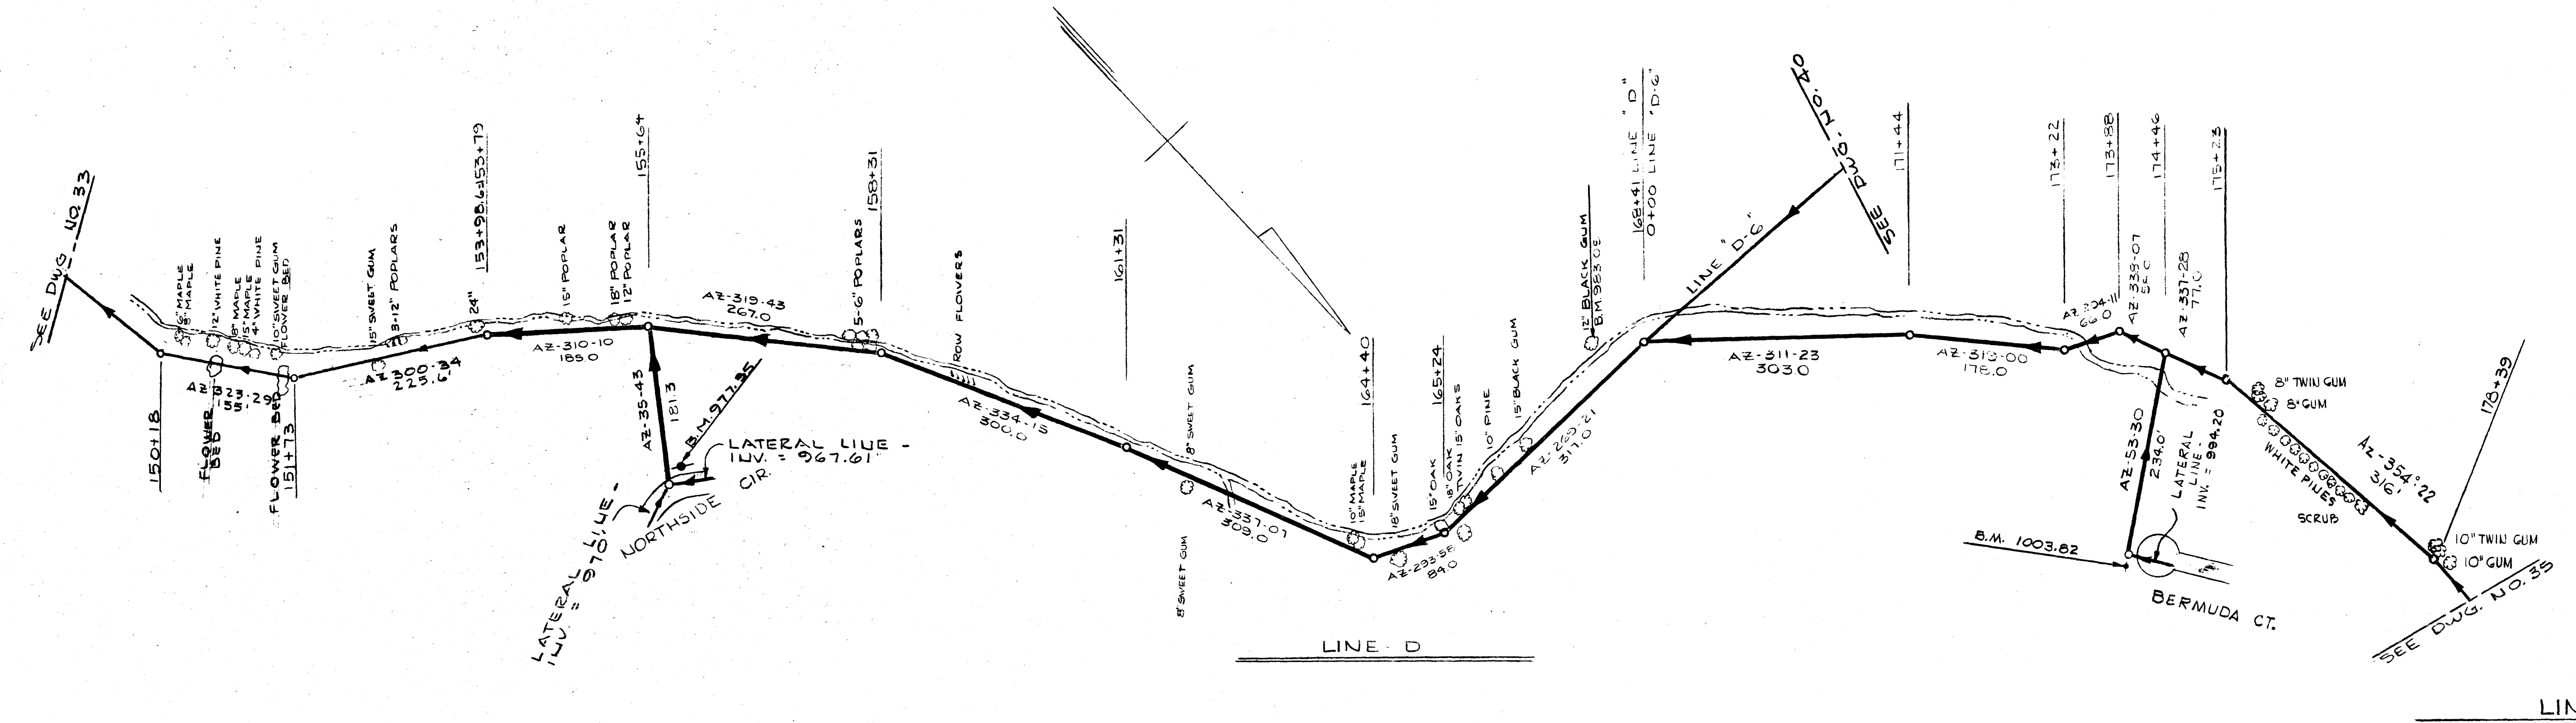

3 4-23-64 JML		REVISED PLAN & PROFILE - BERMUDA CT.	WADE HAMPTON WATER AND SEWER DISTRICT GREENVILLE COUNTY, S. C. PLAN AND PROFILE TRUNK SYSTEM PIEDMONT ENGINEERING SERVICE GREENVILLE, S. C. DRAWN BY _____ CHECKED BY _____ DATE JULY 1963 DWG. NO. 34
2 11-7-64 JED		REVISION @ 0102 LINE D + INV @ BERMUDA CT.	
1 10-28-64 P.D.		GENERAL	

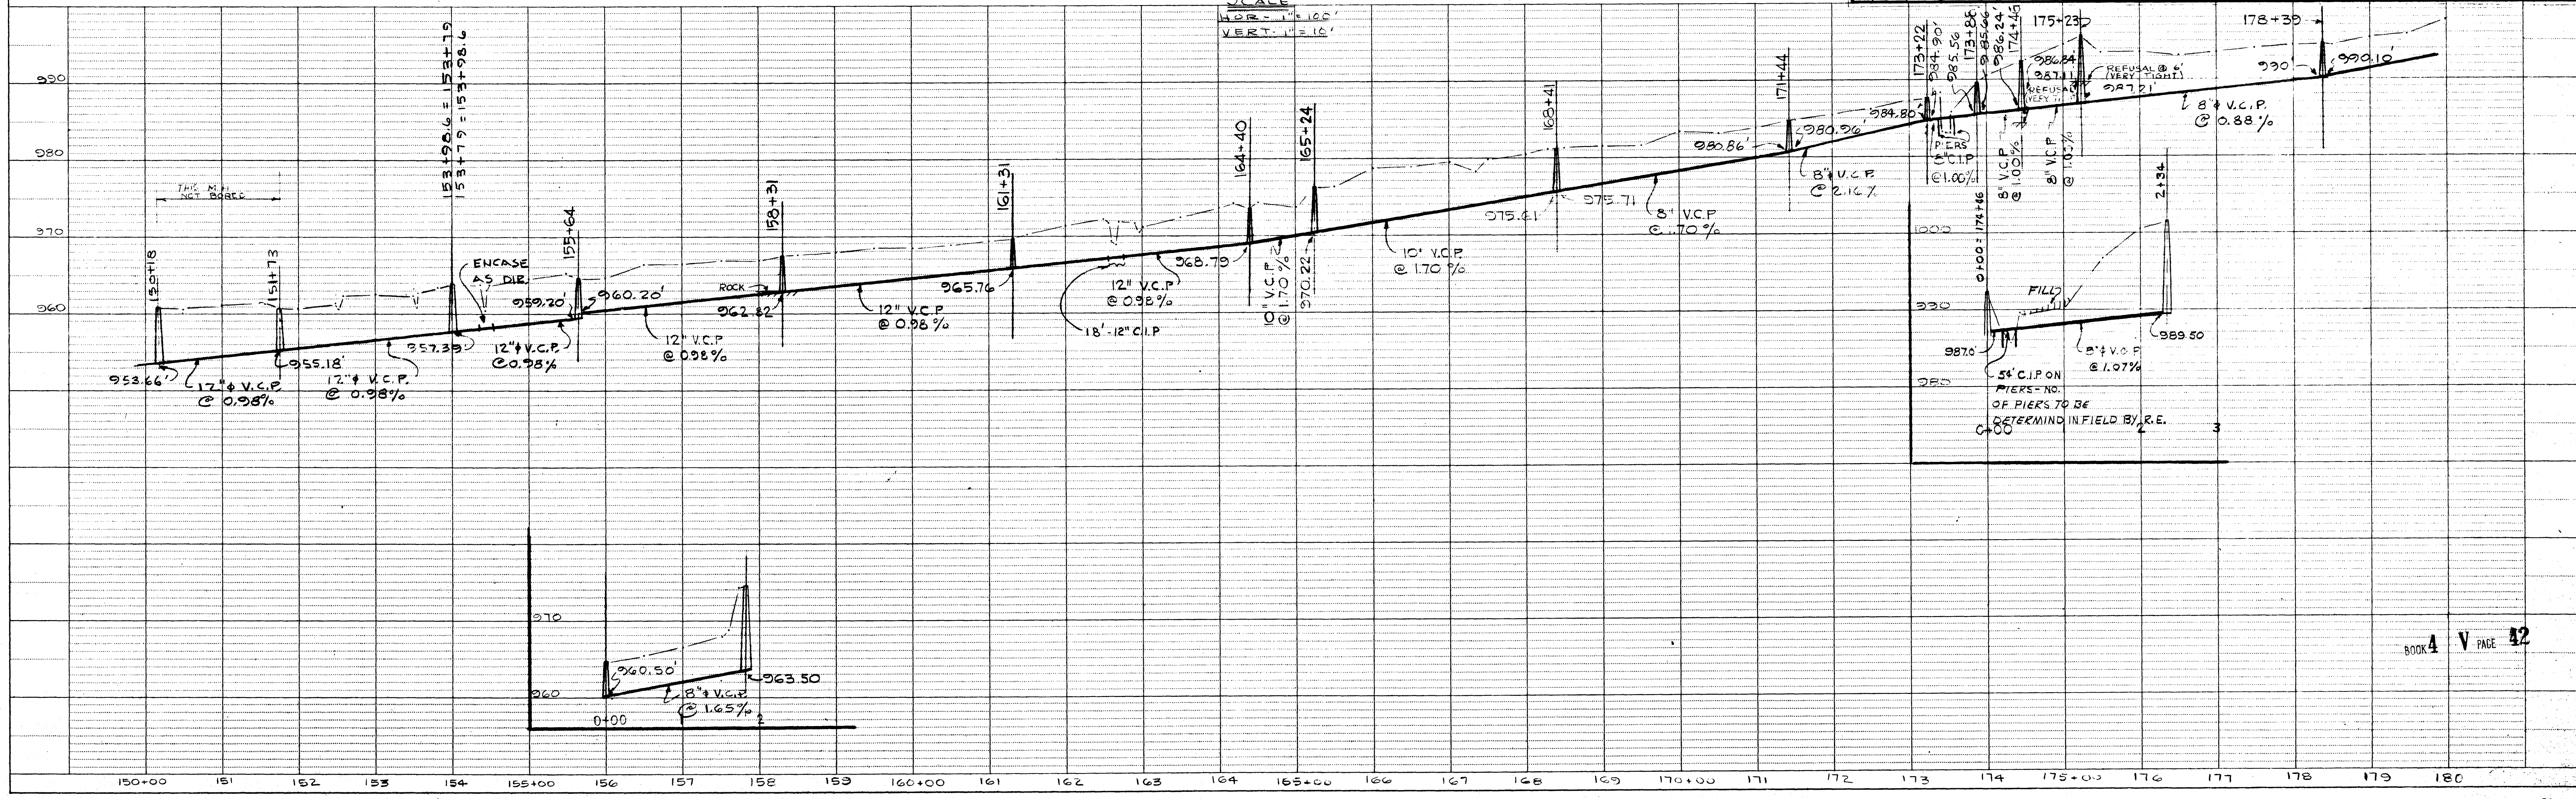

SINGLE PLAN AND PROFILE - DOTTED
 H. A. ROGERS CO. - MINNEAPOLIS - ST. PAUL - DULUTH