



FED. ROAD DIST. NO.	STATE	FEDERAL PROJ. NO.	FISCAL YEAR	SHEET NO.	TOTAL SHEETS

DATE	BY
PLAN	
SURVEYED	
NOTED	
GRADES CHECKED	
ALIGNMENT CHECKED	
RT. OF WAY CHECKED	
NO.	

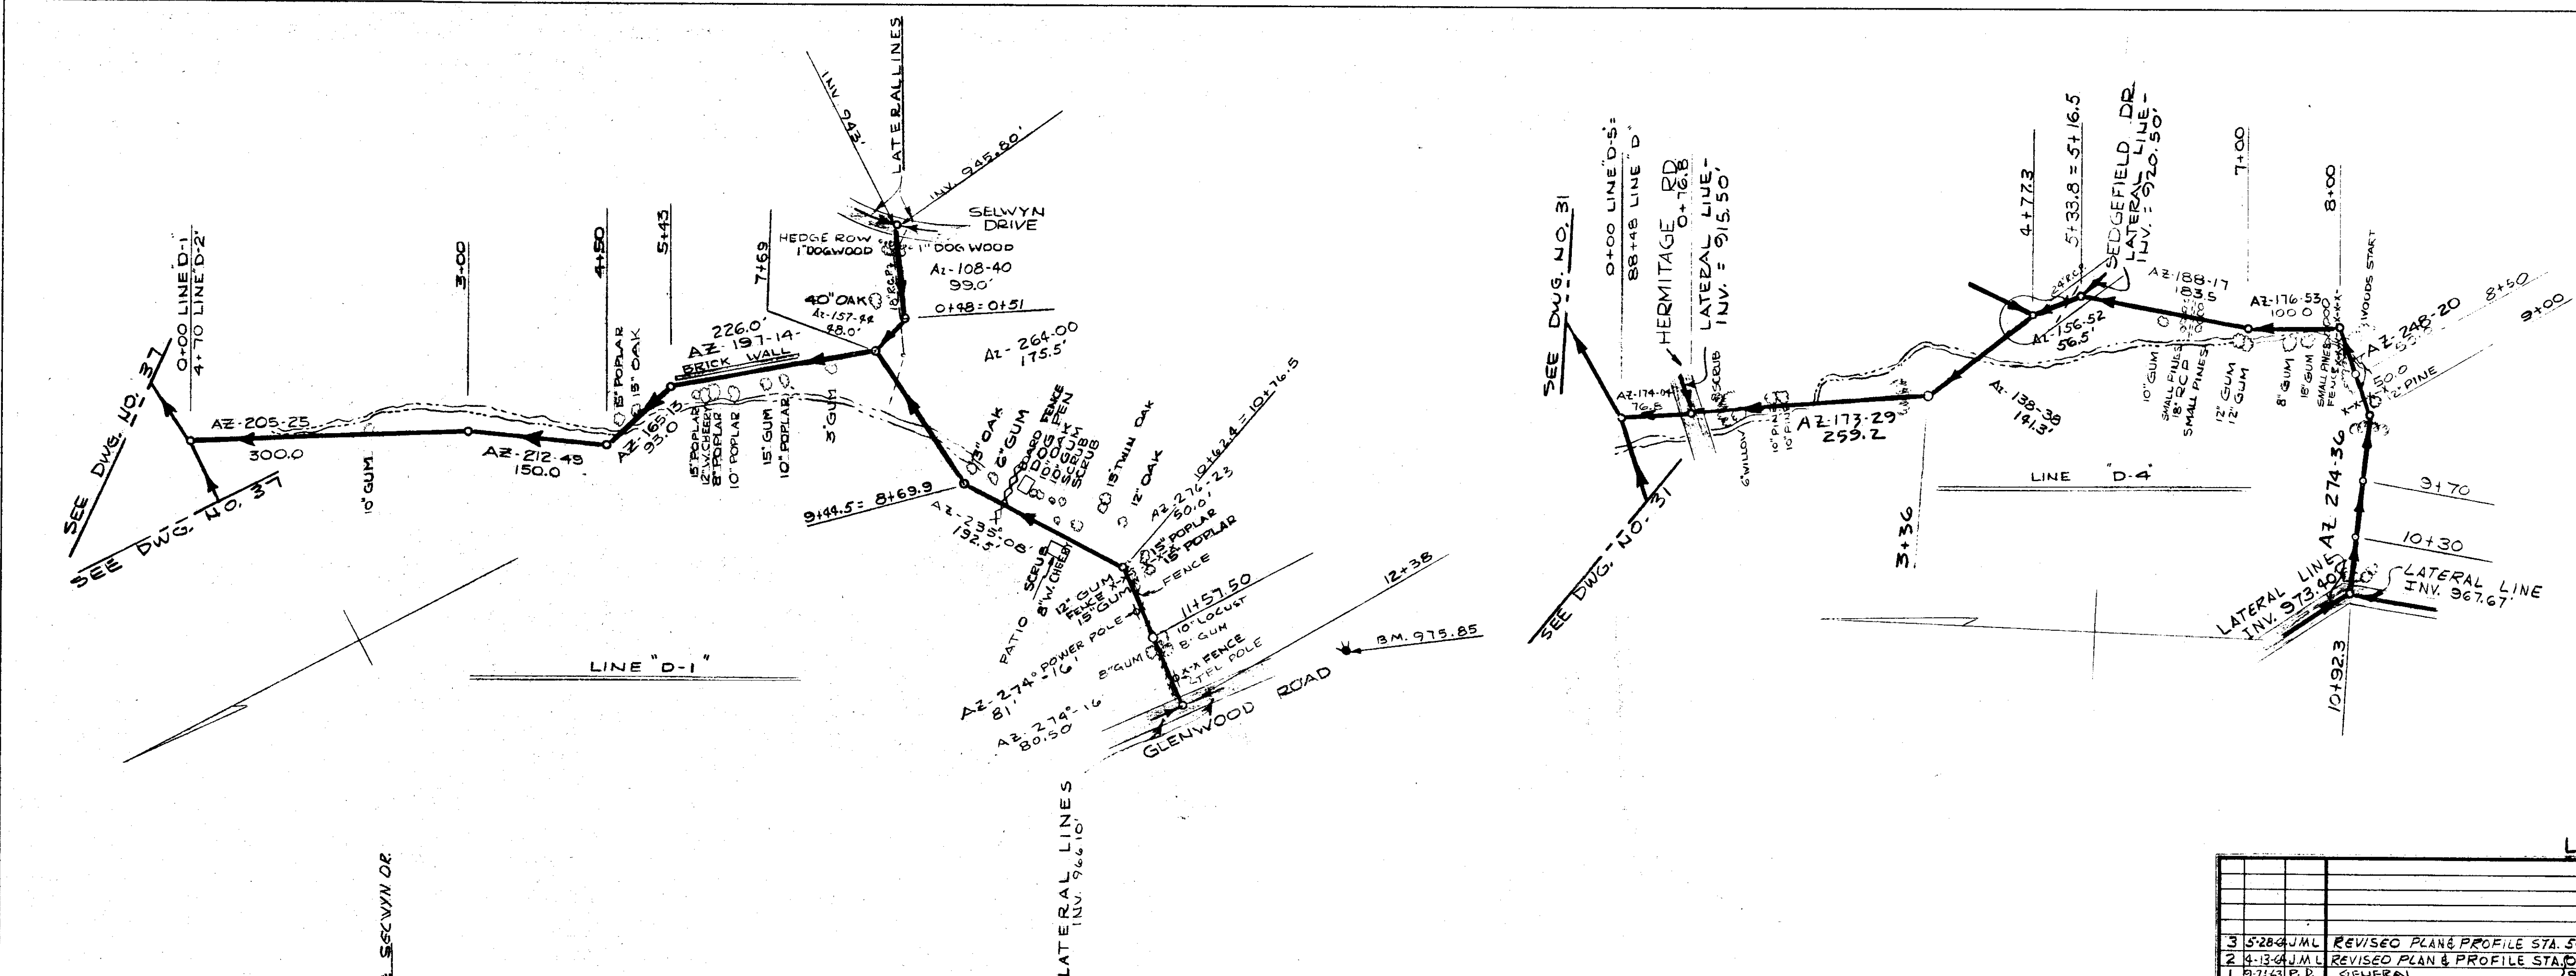

DATE	BY
PROFILE	
SURVEYED	
NOTED	
GRADES CHECKED	
S.M. NOTED	
STRUCTURE NOTATIONS CHECKED	
NO.	

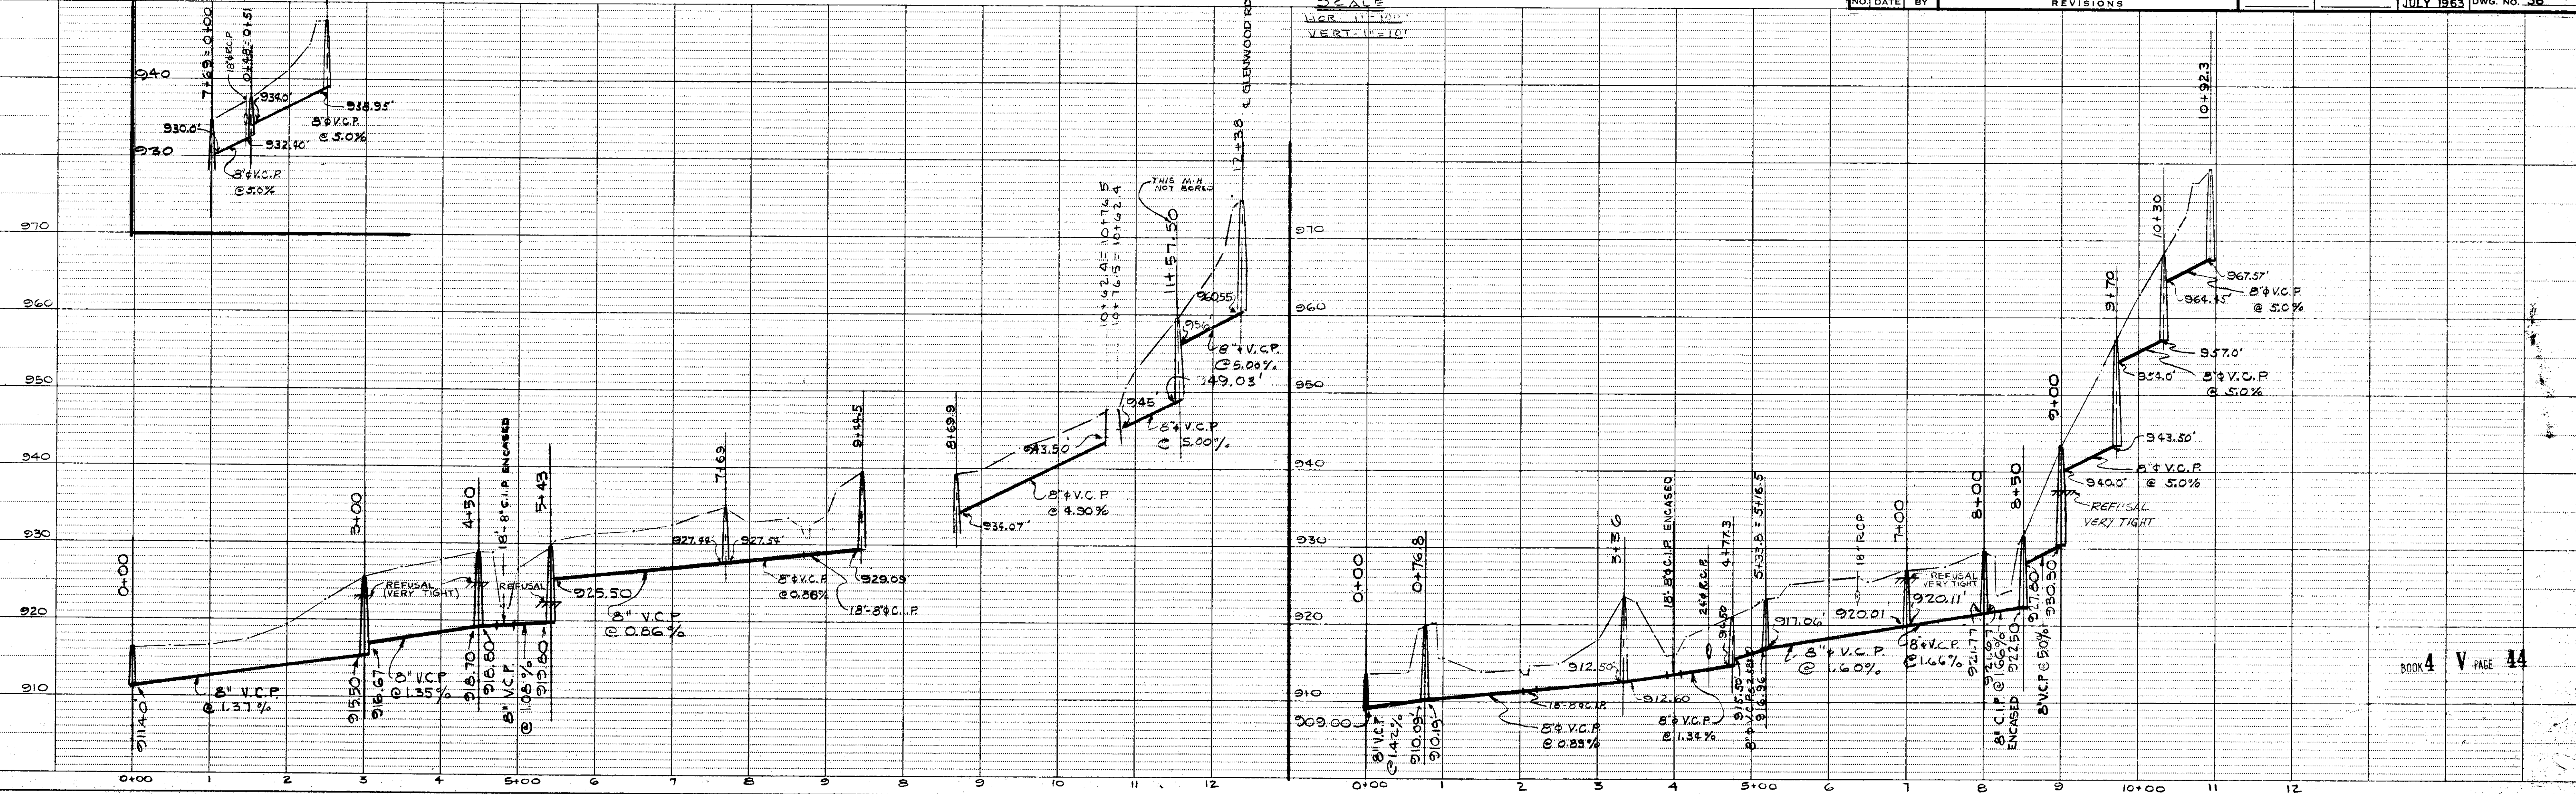

LINE D-1 & LINE D-4		WADE HAMPTON WATER AND SEWER DISTRICT GREENVILLE COUNTY, S.C.	
		<b>PLAN AND PROFILE TRUNK SYSTEM</b>	
3	5284 JML	REVISED PLAN & PROFILE STA. 5+43-9+44.5	DRAWN BY CHECKED BY DATE JULY 1963
2	6134 JML	REVISED PLAN & PROFILE STA. 76.8-5+33.8	
1	2143 RJS	GENERAL (9+00-10+92.3)	
NO. DATE BY		REVISIONS	DWG. NO. 36

SINGLE PLAN AND PROFILE - DOTTED  
H. A. ROGERS CO. - MINNEAPOLIS - ST. PAUL - DULUTH