



PLAN
NO.
DATE
BY
SURVEYED
ALIGNED
CHECKED
RT. OF WAY CHECKED
NOTE BOOK
NO.

PROFILE
NO.
DATE
BY
SURVEYED
GRADES CHECKED
B.M.'S NOTED
STRUCTURE NOTATIONS CHECKED
NOTE BOOK
NO.

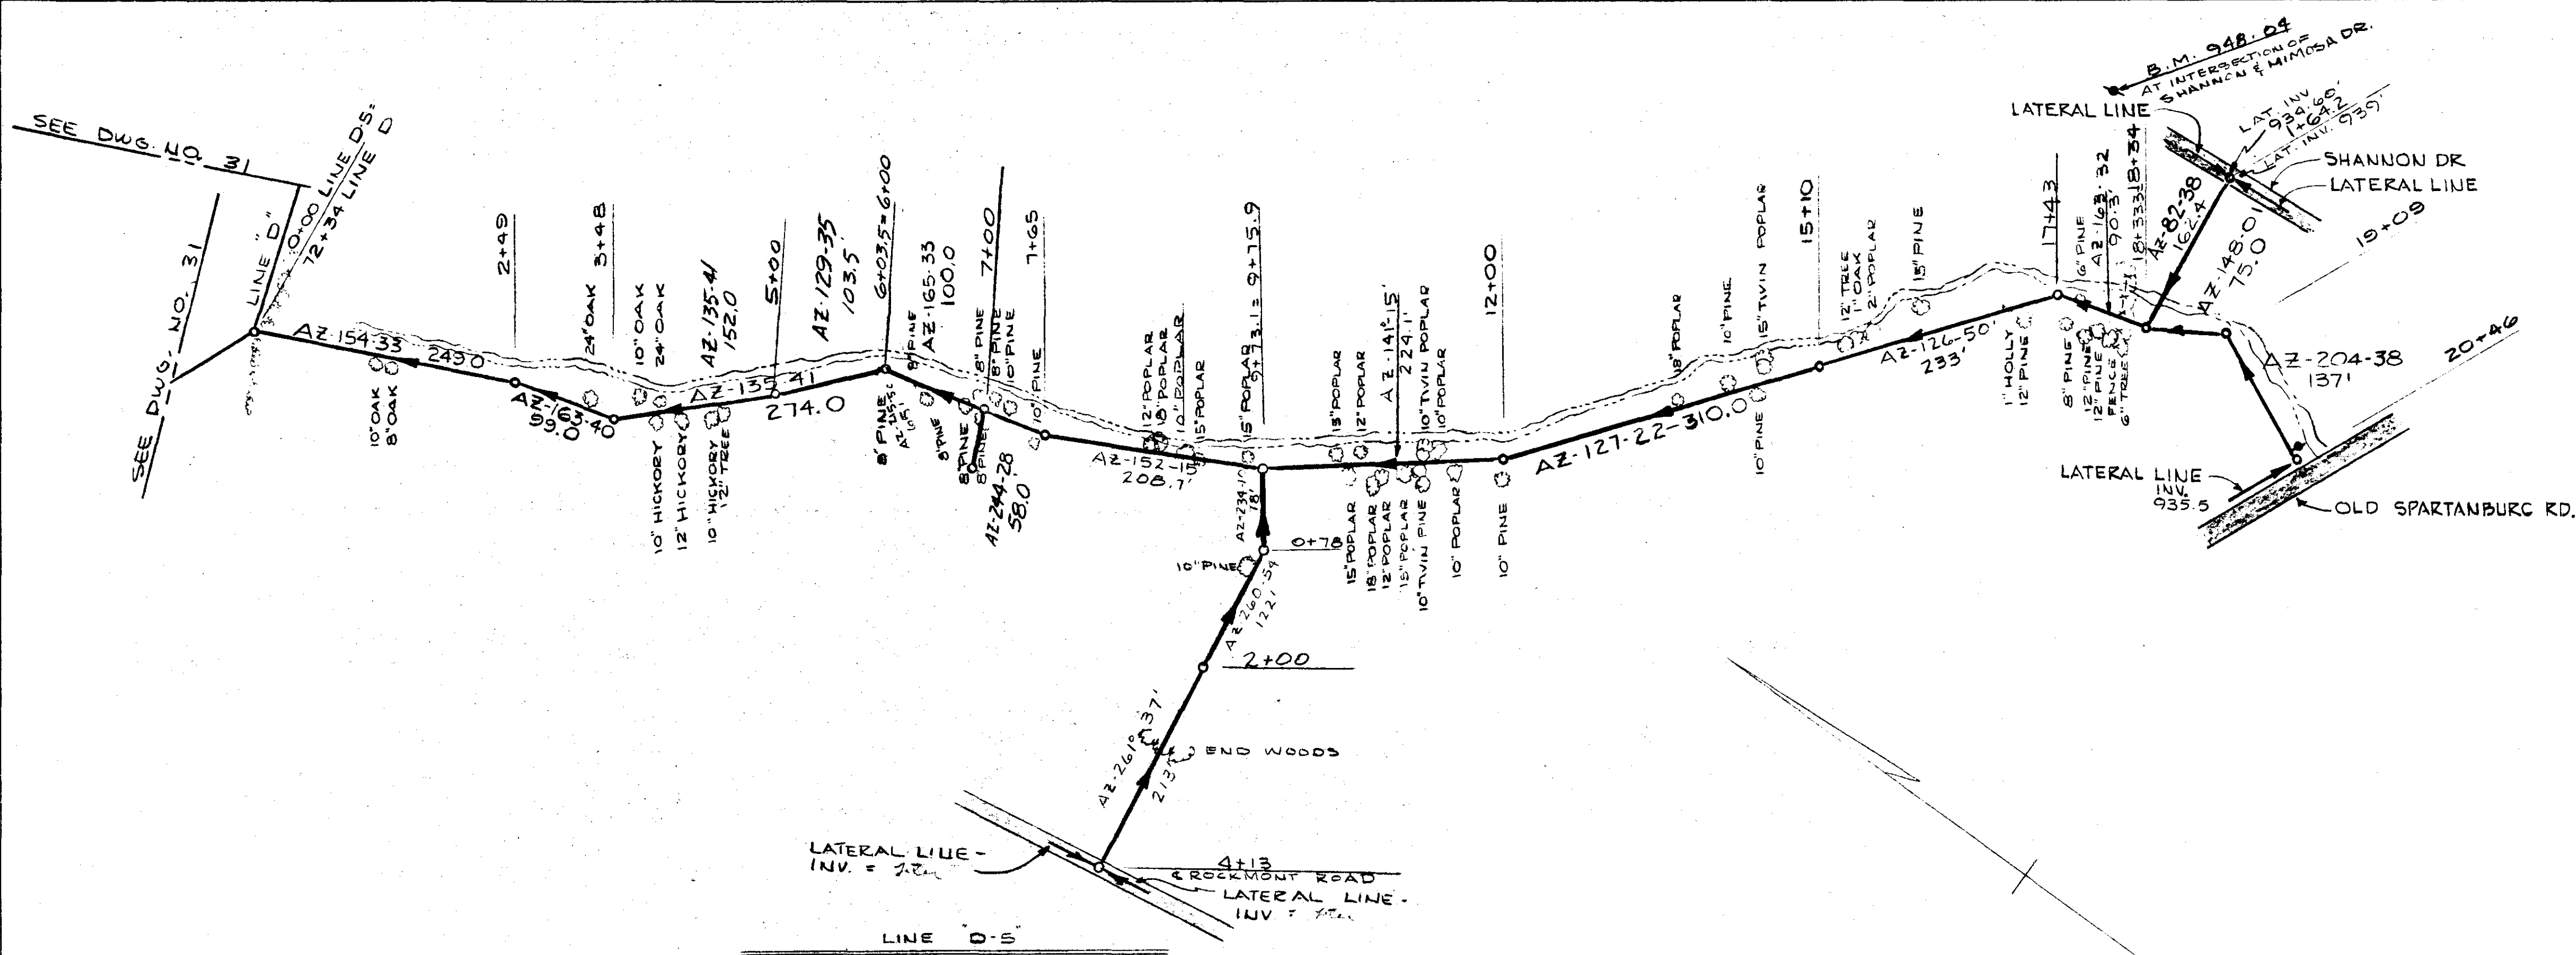

WADE HAMPTON WATER AND SEWER DISTRICT GREENVILLE COUNTY, S. C.	
PLAN AND PROFILE TRUNK SYSTEM	
PIEDMONT ENGINEERING SERVICE GREENVILLE, S. C.	
2 554 JML	REVISED PLAN & PROFILE STA 3+48-7+65
1 423 P.D.	GENERAL
NO. DATE	BY
	REVISIONS
	DRAWN BY
	CHECKED BY
	DATE
	JULY 1963
	DWG. NO. 39

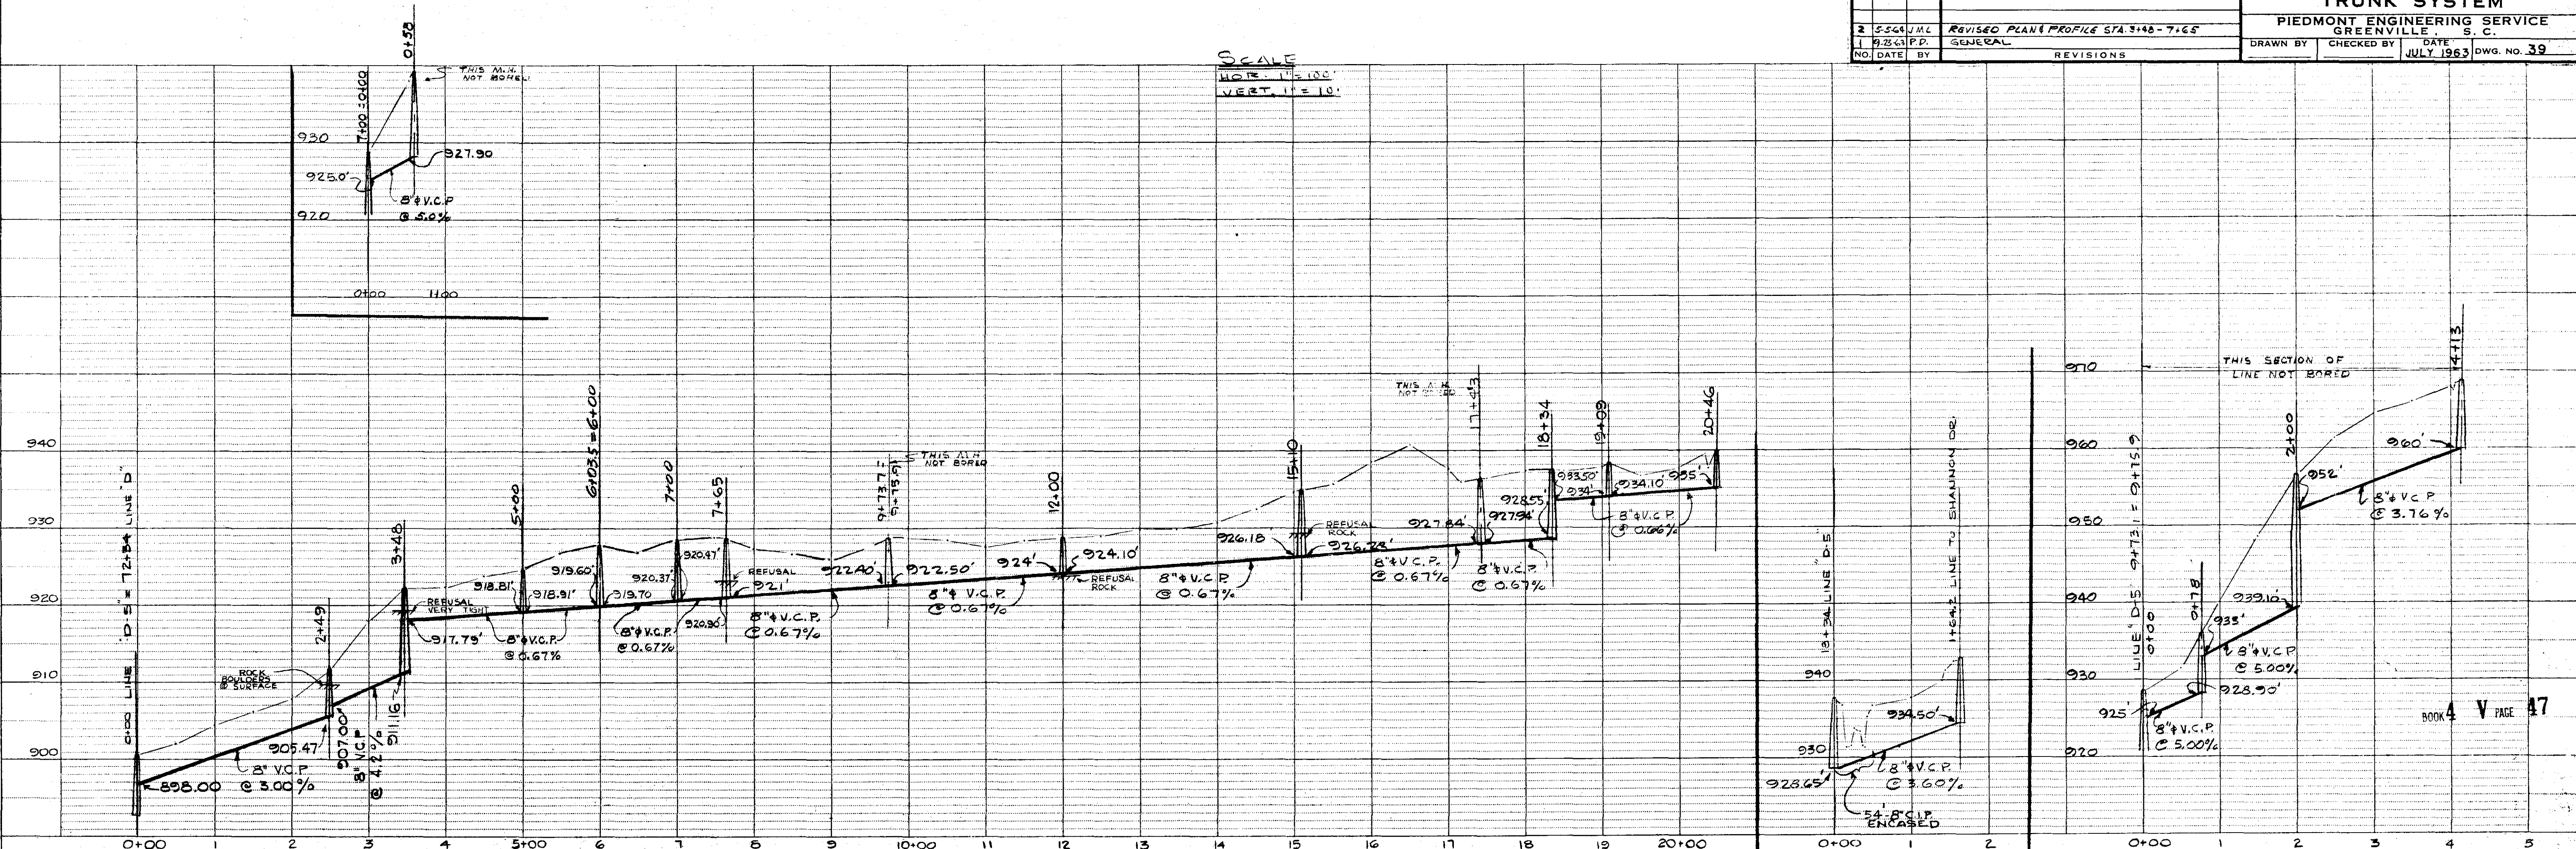

SINGLE PLAN AND PROFILE - DOTTED
H. A. ROGERS CO., MINNEAPOLIS - ST. PAUL - DULUTH