



|                     |       |                   |             |           |              |
|---------------------|-------|-------------------|-------------|-----------|--------------|
| FED. ROAD DIST. NO. | STATE | FEDERAL PROJ. NO. | FISCAL YEAR | SHEET NO. | TOTAL SHEETS |
|                     |       |                   |             |           |              |

|               |                   |
|---------------|-------------------|
| PLAN          | DATE              |
|               | BY                |
| NOTE BOOK NO. | CURVED            |
|               | PLOTTED           |
|               | ALIGNMENT CHECKED |
|               | BY                |

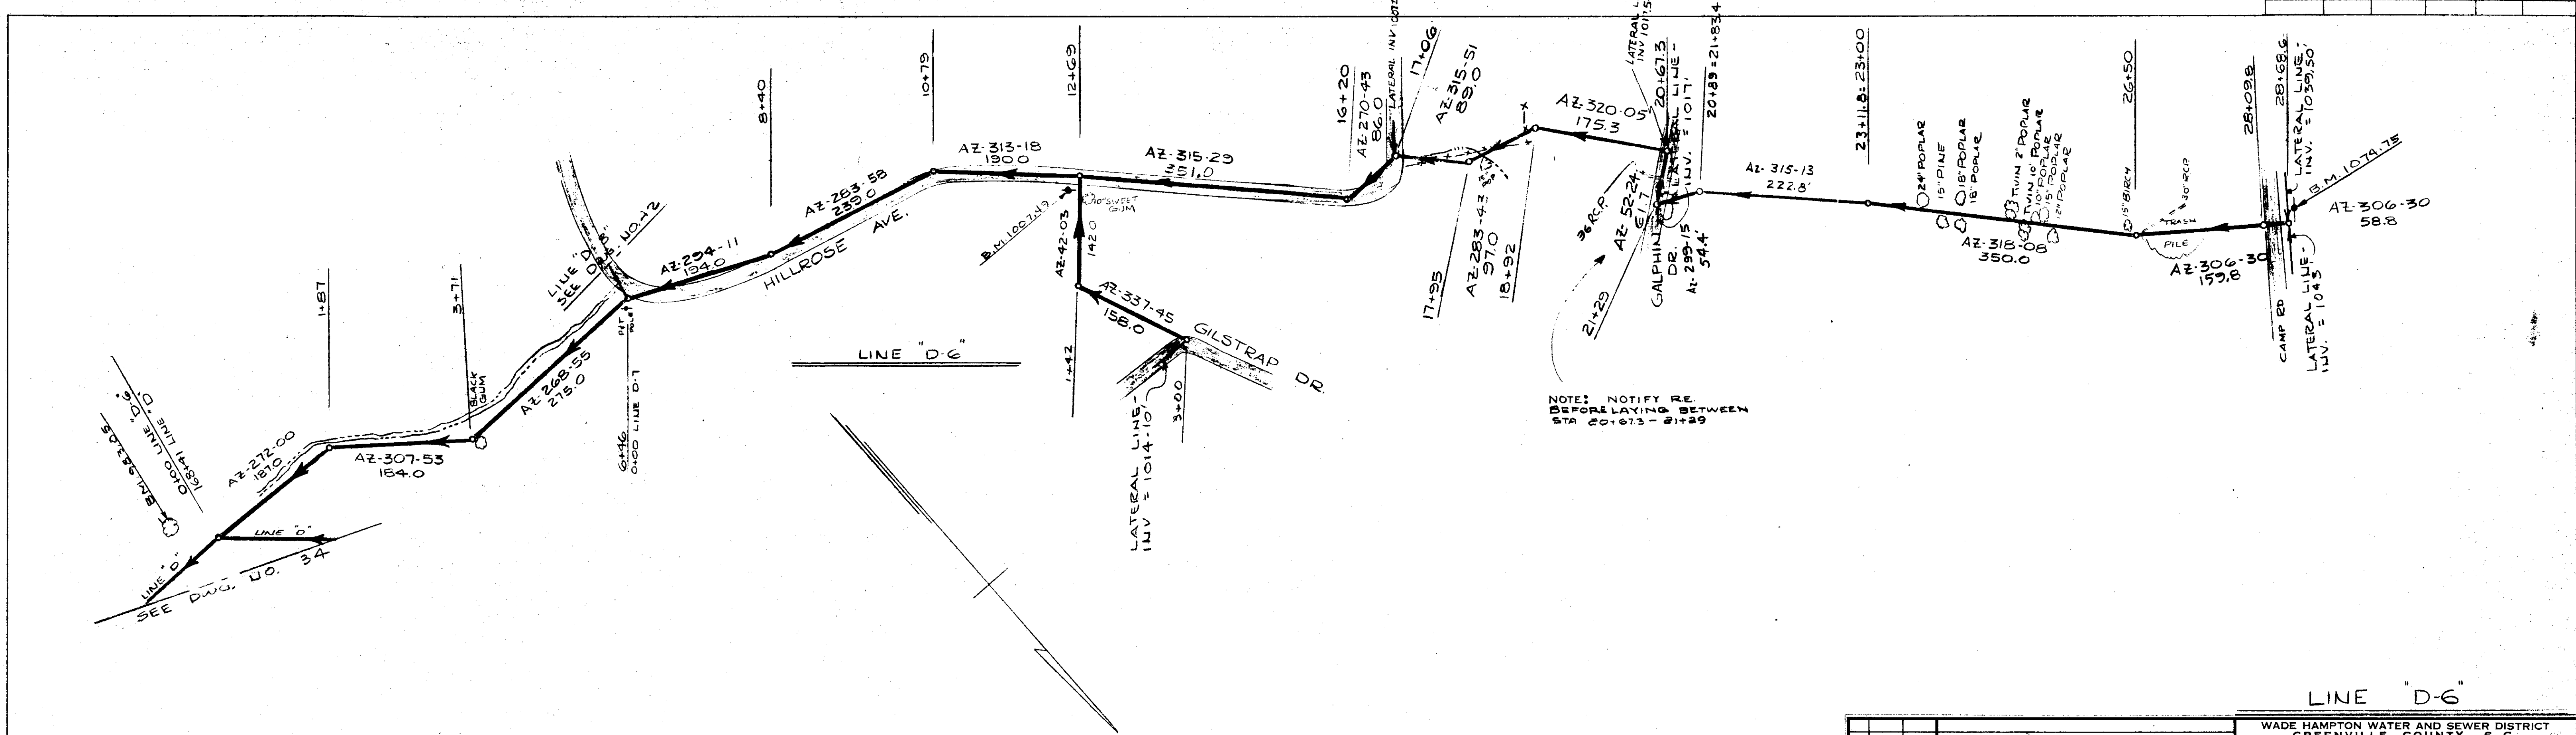

|               |                |
|---------------|----------------|
| PROFILE       | DATE           |
|               | BY             |
| NOTE BOOK NO. | CURVED         |
|               | PLOTTED        |
|               | GRADES CHECKED |
|               | BY             |

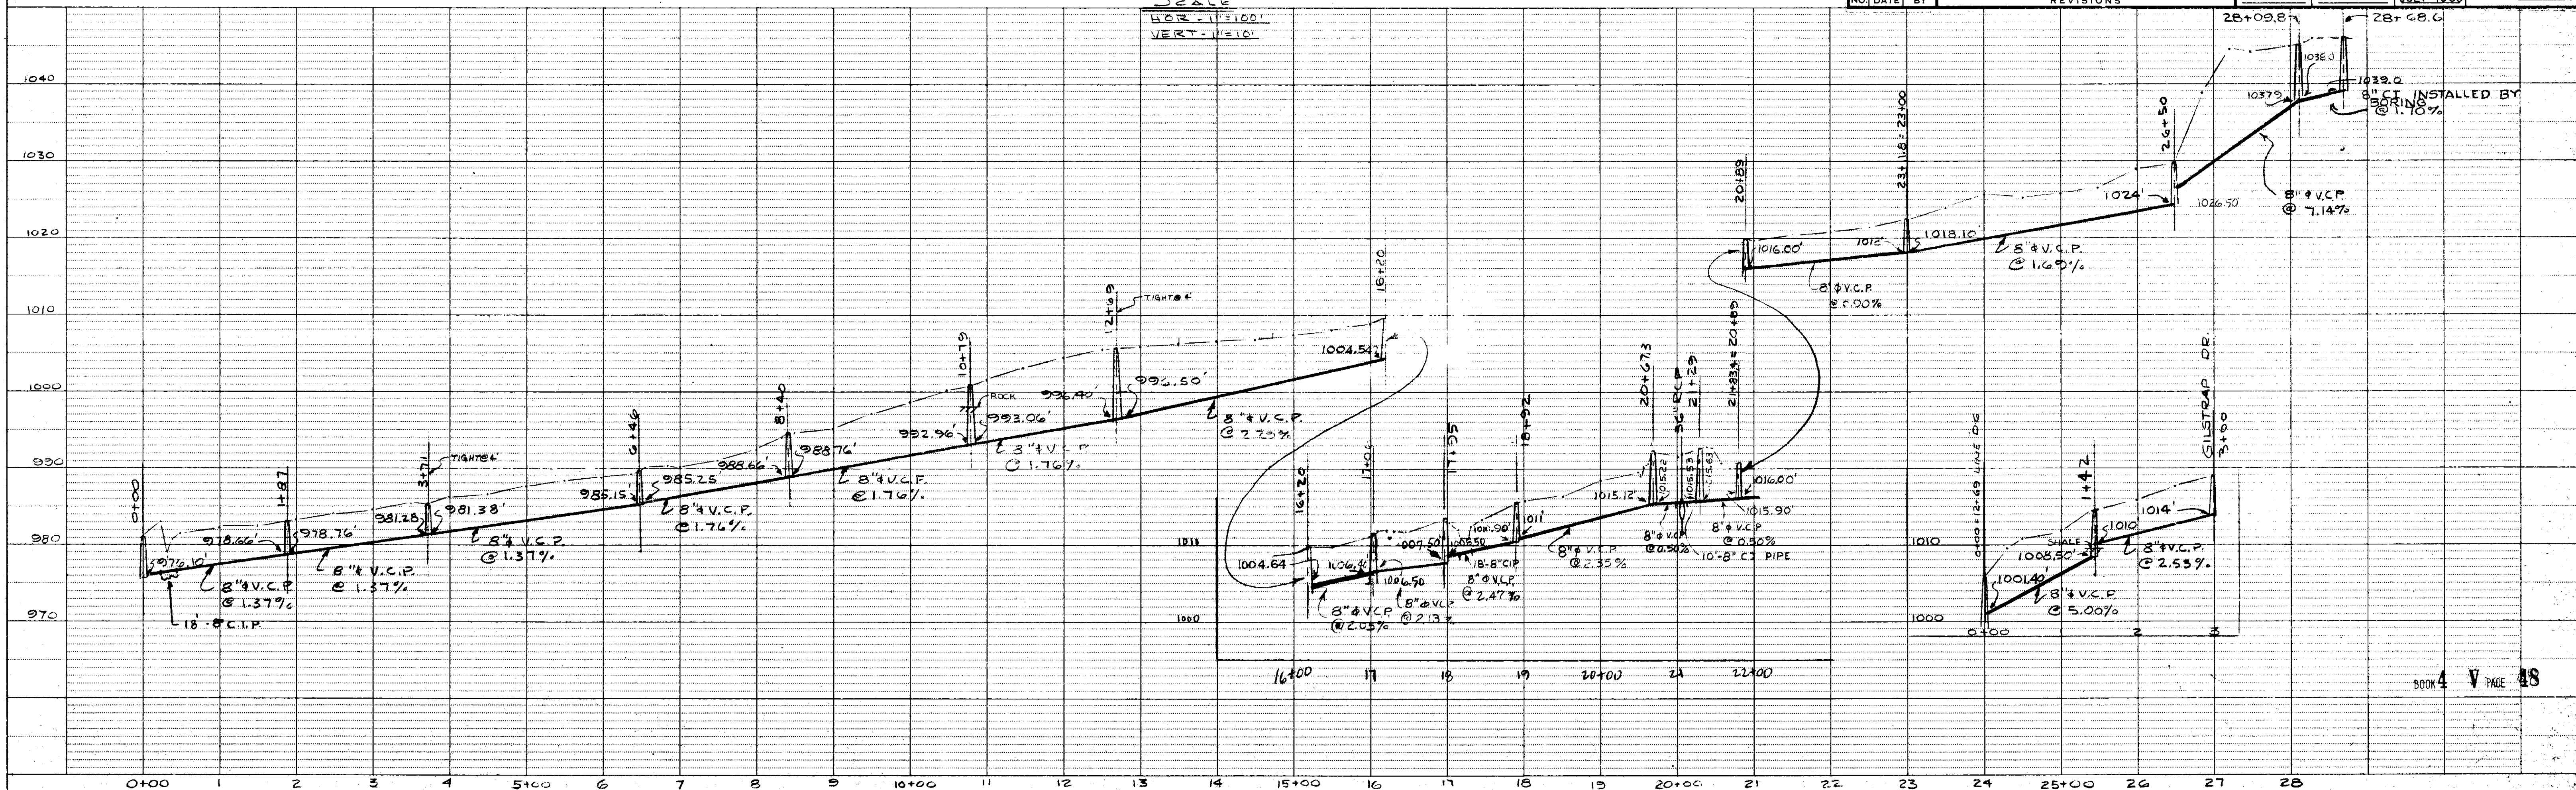

|   |            |
|---|------------|
| WADE HAMPTON WATER AND SEWER DISTRICT<br>GREENVILLE COUNTY, S. C. |            |
| PLAN AND PROFILE<br>TRUNK SYSTEM                                  |            |
| PIEDMONT ENGINEERING SERVICE<br>GREENVILLE, S. C.                 |            |
| DRAWN BY  | CHECKED BY |
| DATE  | DATE       |
| JULY 1963 DWG. NO. 40   |            |

SINGLE PLAN AND PROFILE - DOTTED  
H. A. ROGERS CO. - MINNEAPOLIS - ST. PAUL - DULUTH