


FED. ROAD DIST. NO.	STATE	FEDERAL PROJ. NO.	FISCAL YEAR	SHEET NO.	TOTAL SHEETS
---------------------	-------	-------------------	-------------	-----------	--------------

PLAN	DATE
	BY
NO.	DATE
	BY
SURVEYED	
ALIGNMENT CHECKED	
RT. OF WAY CHECKED	
NOTE BOOK	

FOR CONTINUATION SEE LINE "D" DWG. NO. 40

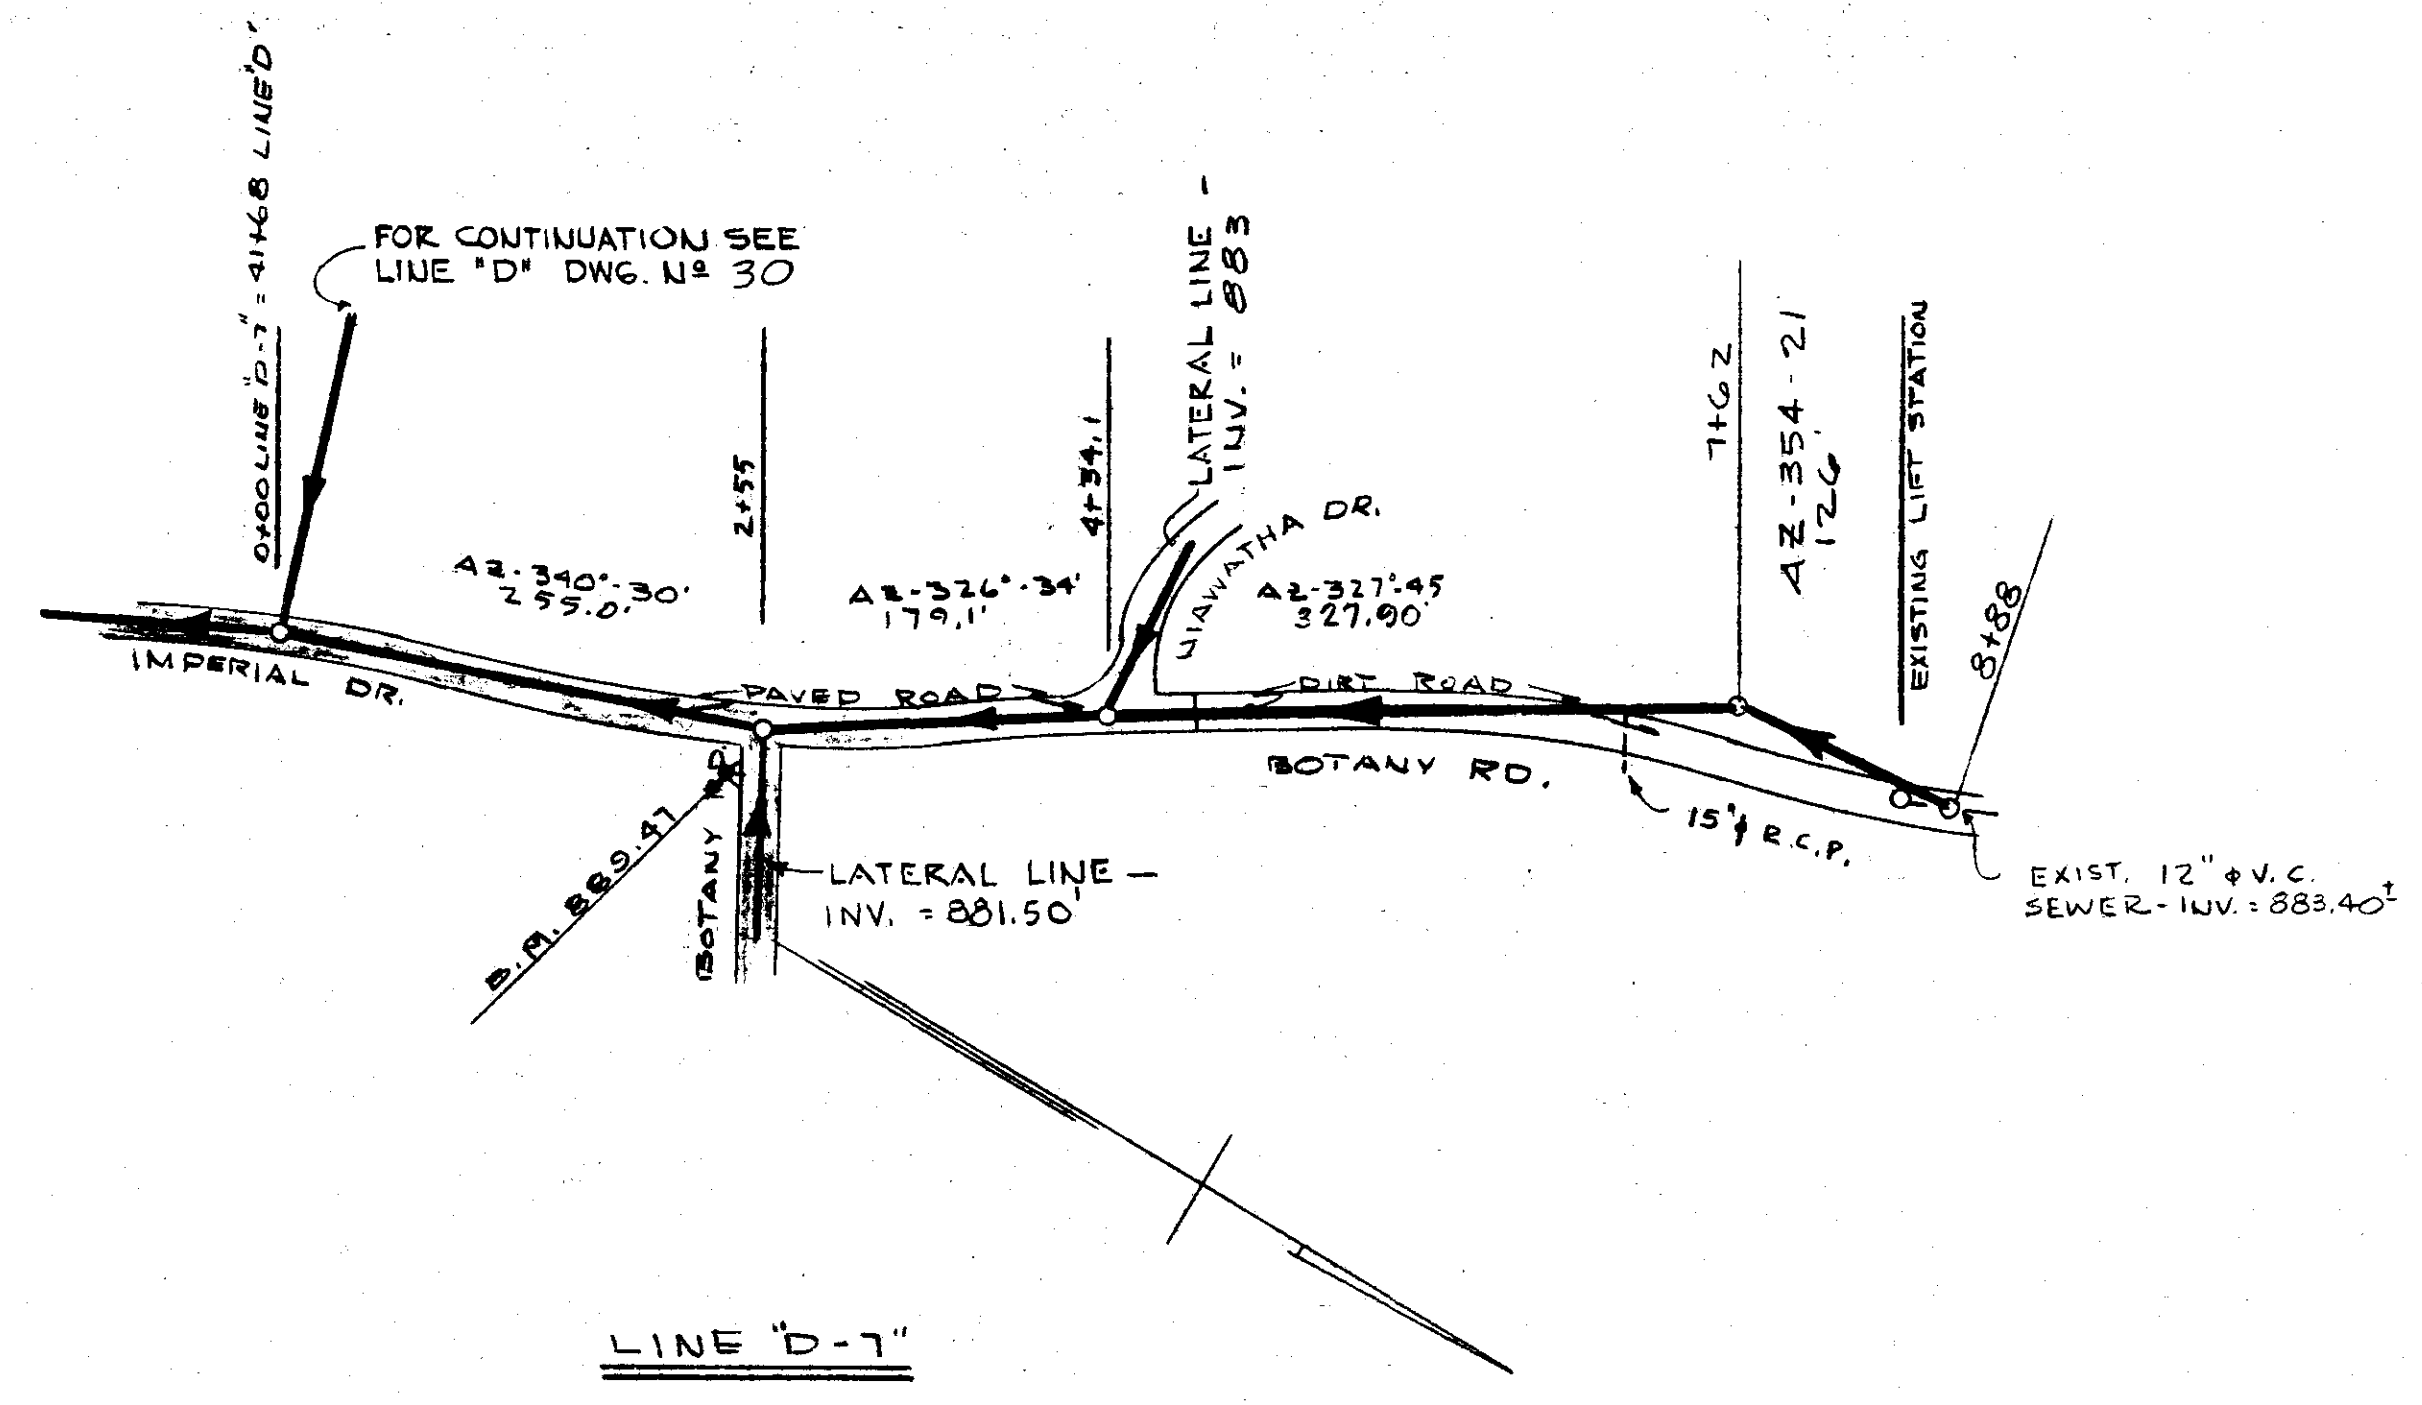


LINE "D-7"

LINE D-7

WADE HAMPTON WATER AND SEWER DISTRICT GREENVILLE COUNTY, S. C.	
PLAN AND PROFILE TRUNK SYSTEM	
PIEDMONT ENGINEERING SERVICE GREENVILLE, S. C.	
DRAWN BY	CHEEAL
CHECKED BY	DATE
	JULY 1963
	DWG. NO. 41

SCALE
 HOR - 1" = 100'
 VERT - 1" = 10'

PROFILE	DATE
	BY
NO.	DATE
	BY
SURVEYED	
GRADES CHECKED	
STRUCTURE NOTATIONS CHKD	
NOTE BOOK	

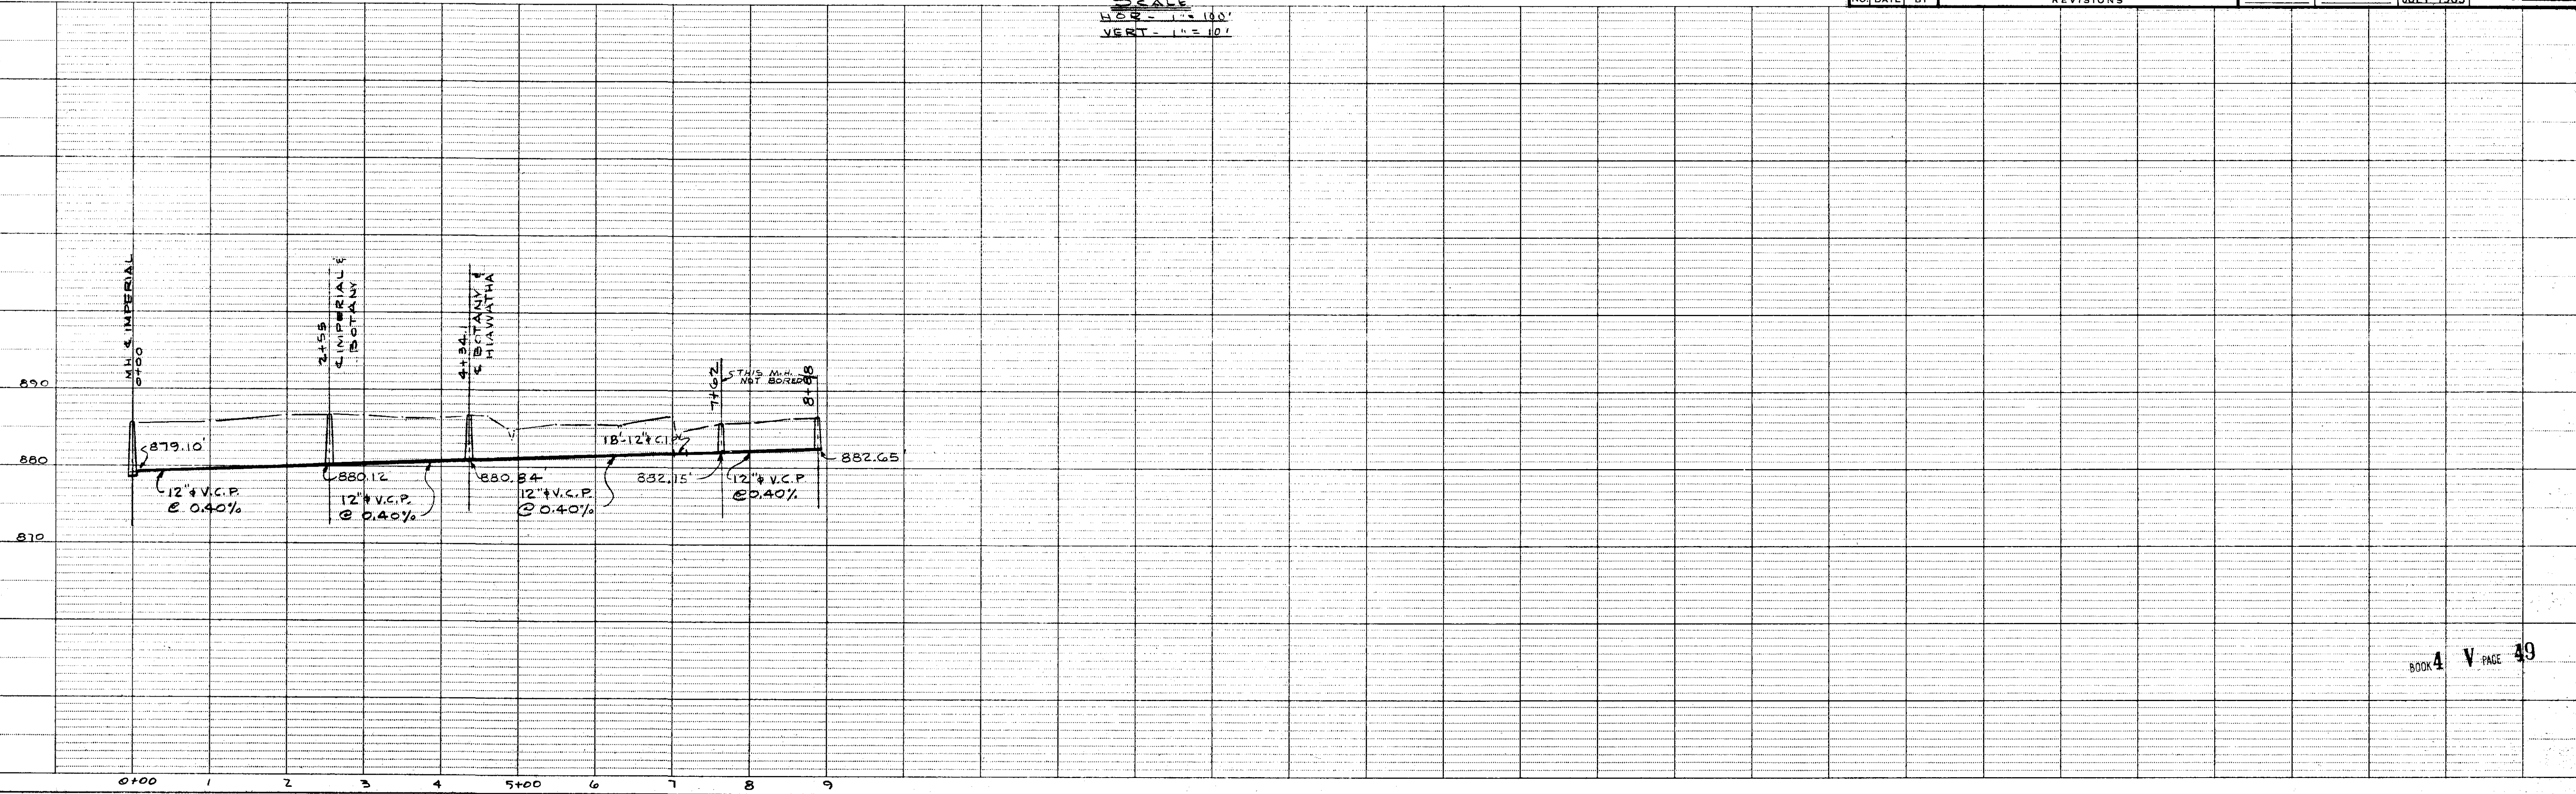

BOOK 4 V PAGE 49