



FED. ROAD DIST. NO.	STATE	FEDERAL PROJ. NO.	FISCAL YEAR	SHEET NO.	TOTAL SHEETS
---------------------	-------	-------------------	-------------	-----------	--------------

PLAN	DATE
SURVEYED	
ALLOTMENT CHECKED	
NOTE BOOK NO.	

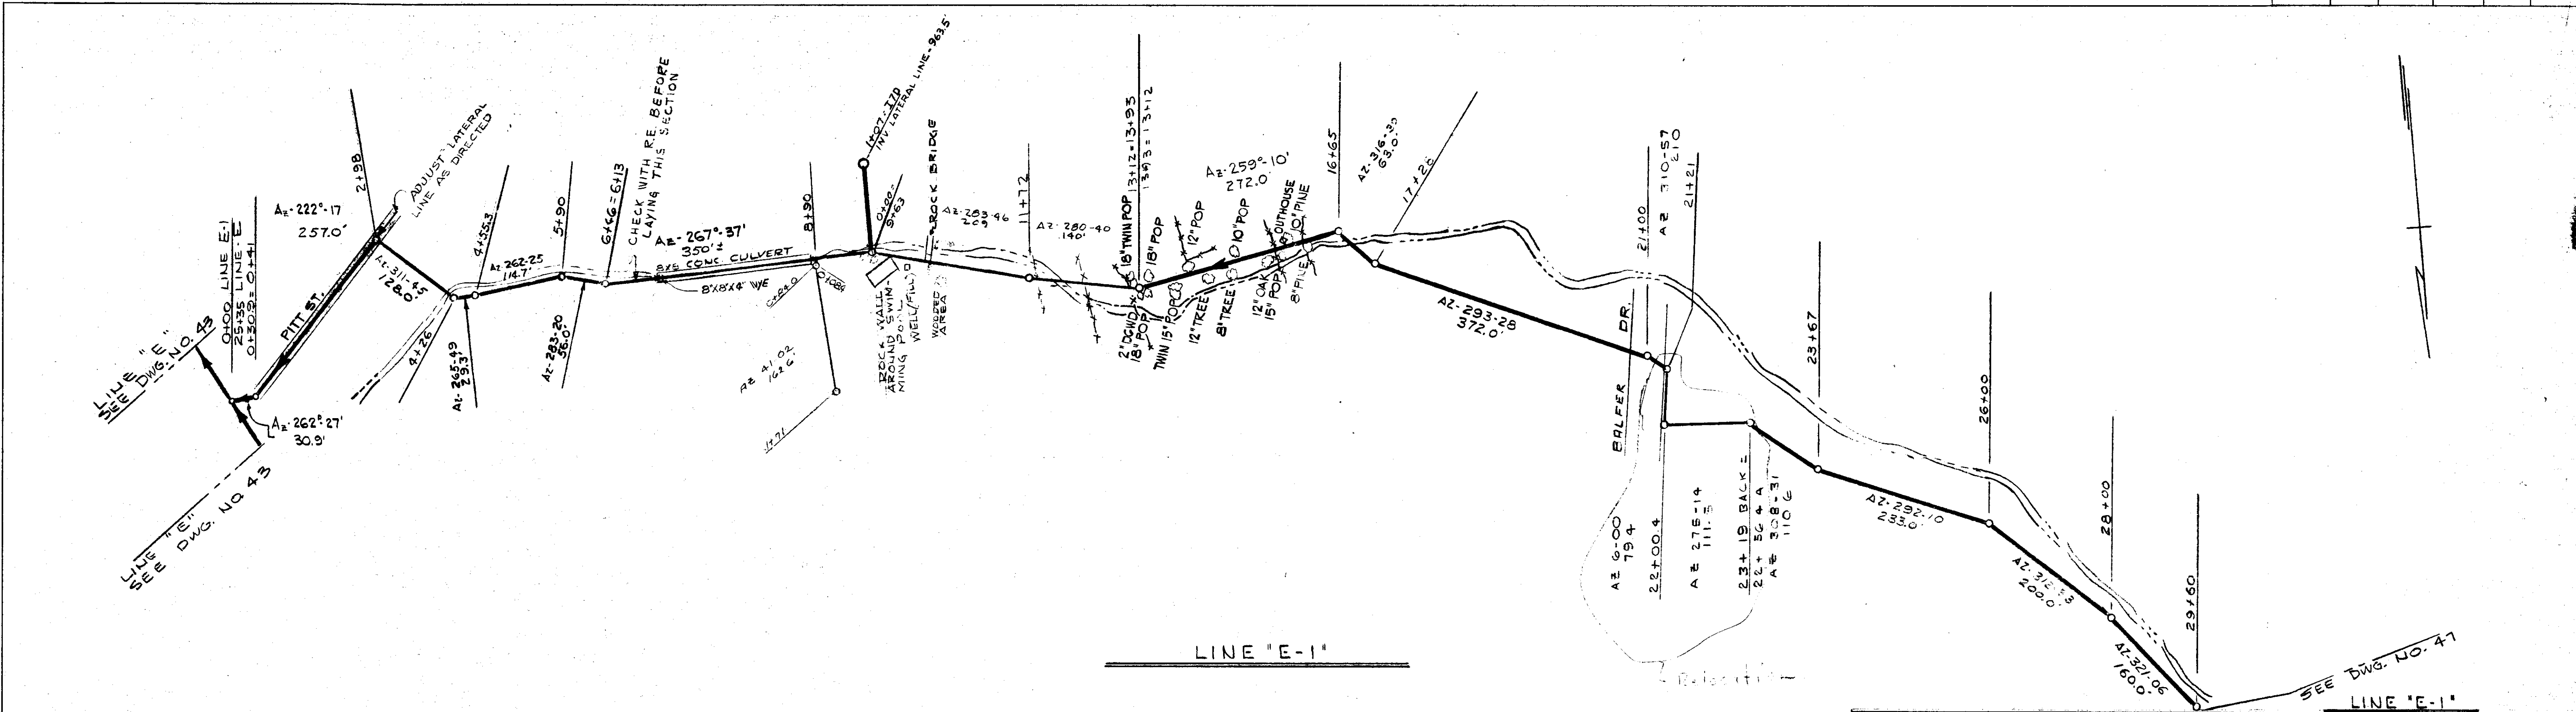

PROFILE	DATE
SURVEYED	
GRADES CHECKED	
NOTE BOOK NO.	

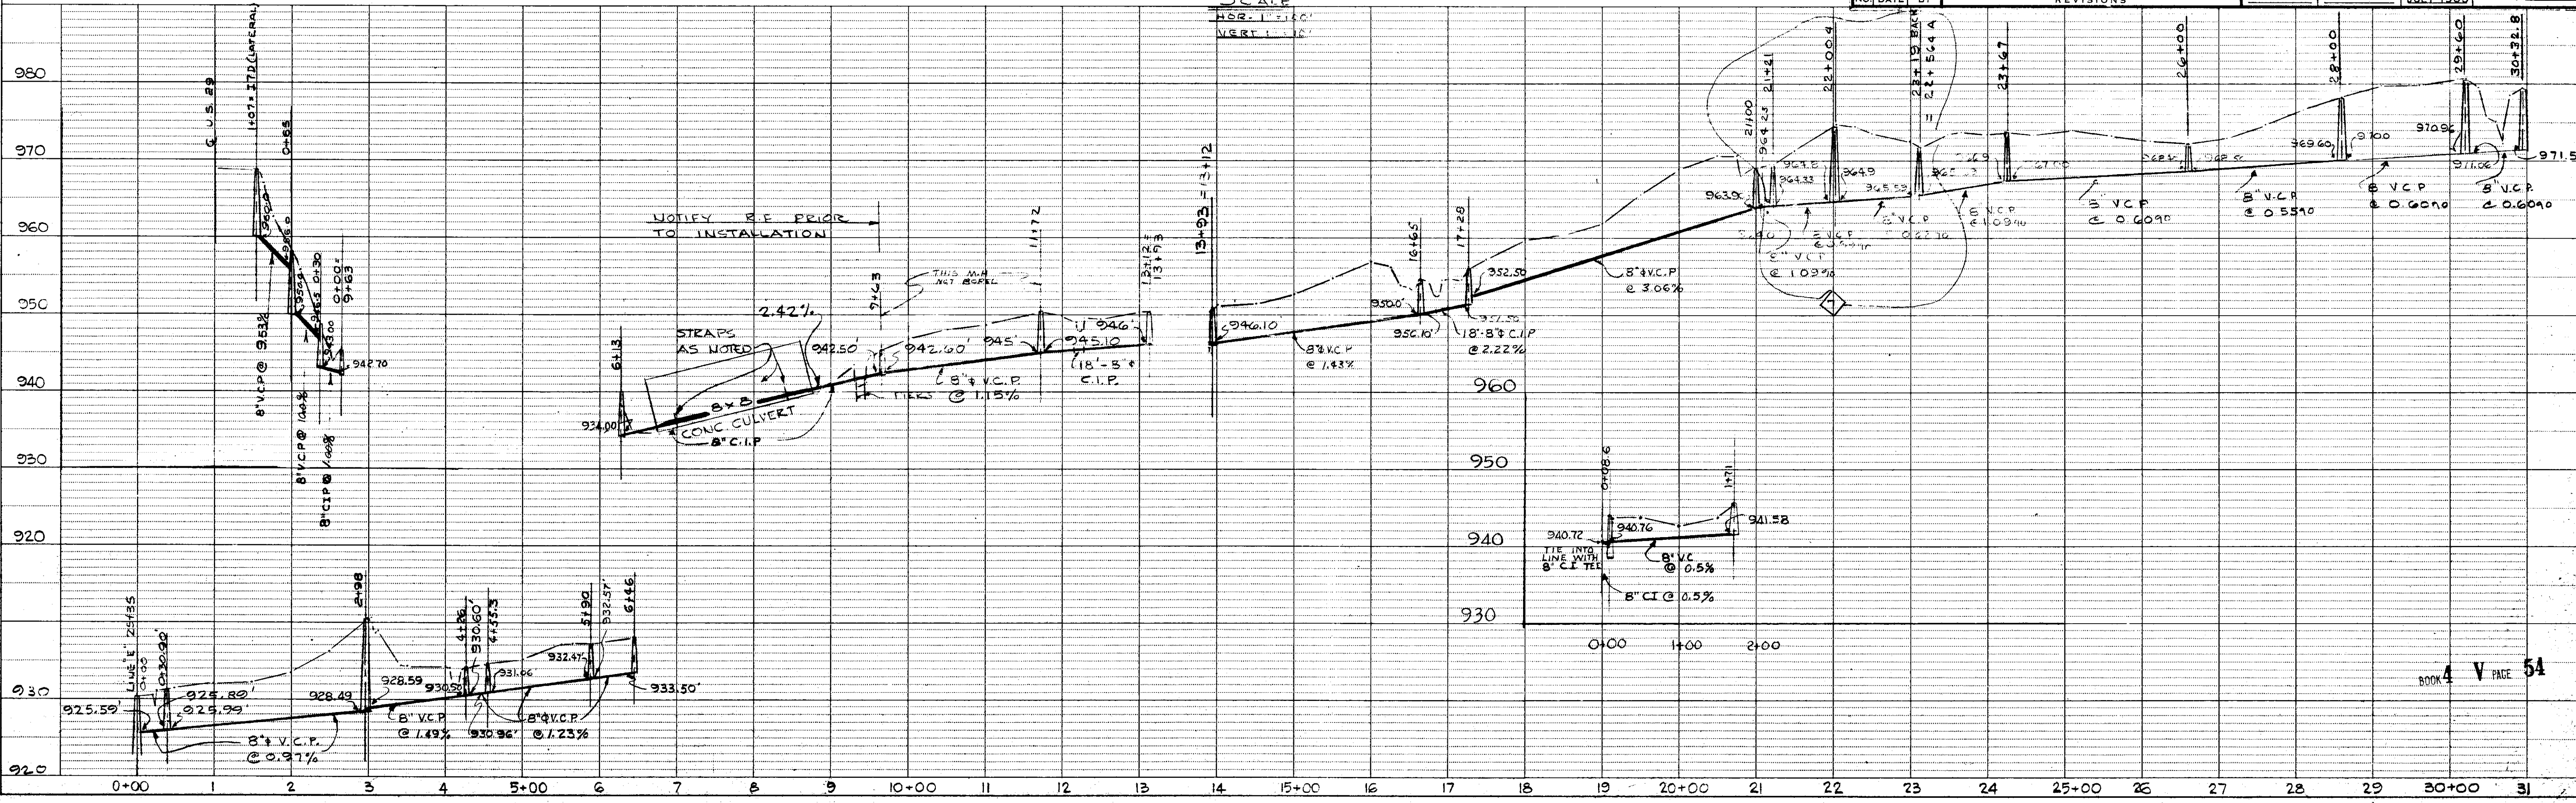

NO.	DATE	BY	REVISIONS
7	7-3-71	AD	RELOCATED LINE STA 21+21 - 23+91
6	3-29-69	AD	REVISIONS PLAN & PROFILE STA 13+92 - 17+28
5	8-19-64	AD	REVISED PLAN & PROFILE STA 2+99 - 6+48
4	8-19-64	AD	ADDED A SECTION OF LINE AT STA 8+90
3	3-30-64	JML	REVISED PLAN & PROFILE STA 13+92 - 30+32.8
2	2-18-64	PEB	ADDED A SECTION OF LINE AT STA 9+23
1	9-22-63	PEB	GENERAL

WADE HAMPTON WATER AND SEWER DISTRICT,
GREENVILLE COUNTY, S. C.

PLAN AND PROFILE
TRUNK SYSTEM

PIEDMONT ENGINEERING SERVICE
GREENVILLE, S. C.

DRAWN BY: _____ CHECKED BY: _____ DATE: JULY 1963 DWG. NO. 46

SINGLE PLAN AND PROFILE - DOTTED
H. A. ROGERS CO. - MINNEAPOLIS - ST. PAUL - DULUTH