



FED. ROAD DIST. NO.	STATE	FEDERAL PROJ. NO.	FISCAL YEAR	SHEET NO.	TOTAL SHEETS
---------------------	-------	-------------------	-------------	-----------	--------------

PLAN	SURVEYED	BY	DATE
	ALIGNED		
	RT. OF WAY CHECKED		
	NO.		

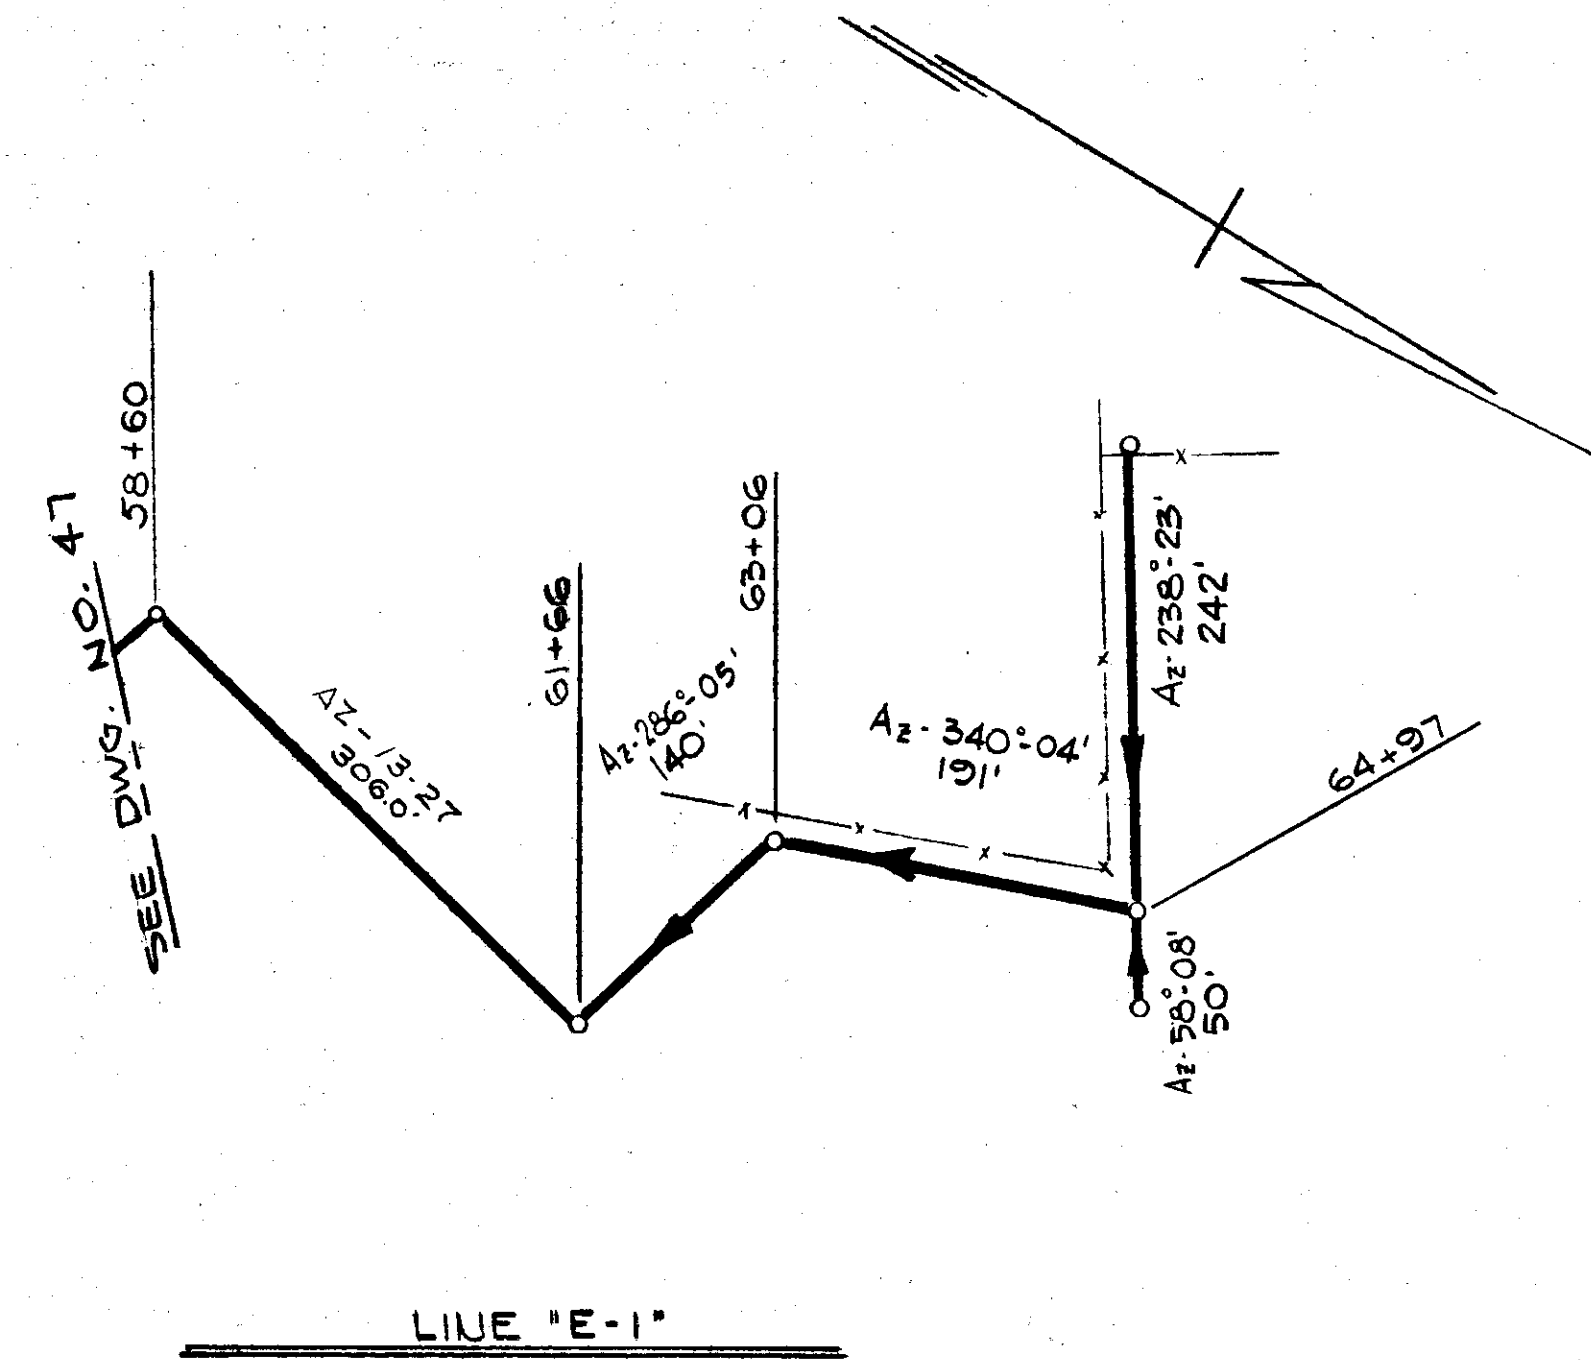

LINE "E-1"		WADE HAMPTON WATER AND SEWER DISTRICT GREENVILLE COUNTY, S. C.	
24-104 JML		REVISIONS	
1-23-63 P13		GENERAL	
NO. DATE BY		DRAWN BY CHECKED BY DATE	
		JULY 1963 DWG. NO. 48	

PROFILE	SURVEYED	BY	DATE
	GRADES CHECKED		
	STRUCTURE NOTATIONS CHNG.		
	NO.		

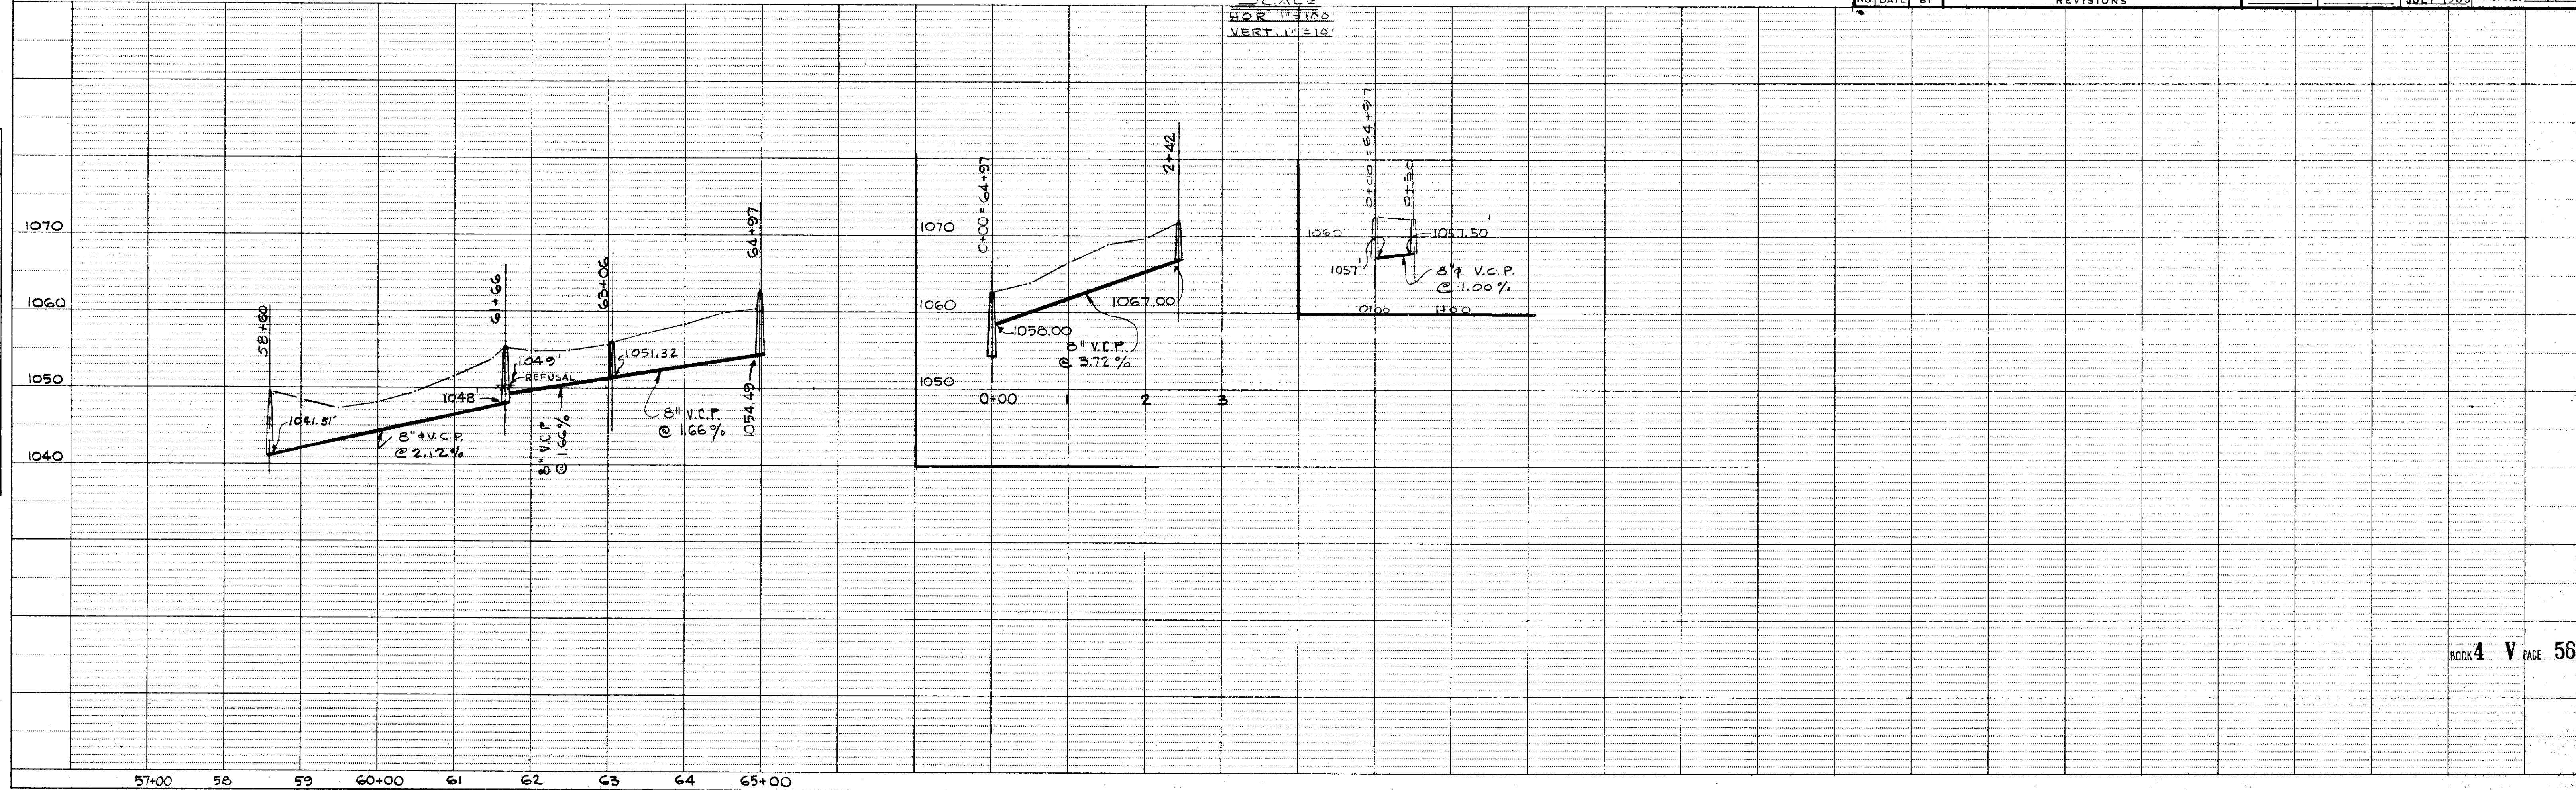

SINGLE PLAN AND PROFILE - DOTTED
H. A. ROGERS CO. - MINNEAPOLIS - ST. PAUL - DULUTH