


INDEX SHEET

SHEET NO.	DESCRIPTION
1	COVER SHEET
2	INDEX MAP
3 & 4	SEWER LINES EAST LAGOON & STATE PARK DRAINAGE AREAS
5	SEWER LINES EAST LAGOON DRAINAGE AREA
6	SEWER LINES & FORCE MAIN EAST LAGOON & TUBBS MTN. DRAINAGE AREAS
7 & 8	SEWER LINES TUBBS MTN. DRAINAGE AREA
9	SEWER LINES WEST LAGOON & EAST LAGOON DRAINAGE AREAS
10	SEWER LINES EAST LAGOON DRAINAGE AREA
11	SEWER LINES WEST LAGOON DRAINAGE AREA
12	WEST LAGOON
13	EAST LAGOON
14	AERATOR PLATFORM & ACCESS PIER DETAILS
15	DETAILS - CONCRETE OUTLET STRUCTURES
16	DETAILS - CONCRETE PIERS, FENCE & SIGN
17	DETAILS: MANHOLES & SERVICE CONNECTIONS
18	PUMPING STATION
19	EJECTOR STATION
20	PUMPING STATION & EJECTOR STATION SITES
21 THRU 28	PROFILES EAST LAGOON DRAINAGE AREA
29 & 30	PROFILES EAST LAGOON & STATE PARK ROAD DRAINAGE AREAS
31 THRU 38	PROFILES TUBBS MOUNTAIN ROAD DRAINAGE AREA
39 THRU 42	PROFILES WEST LAGOON DRAINAGE AREA
43	ELECTRICAL PLAN & DETAILS

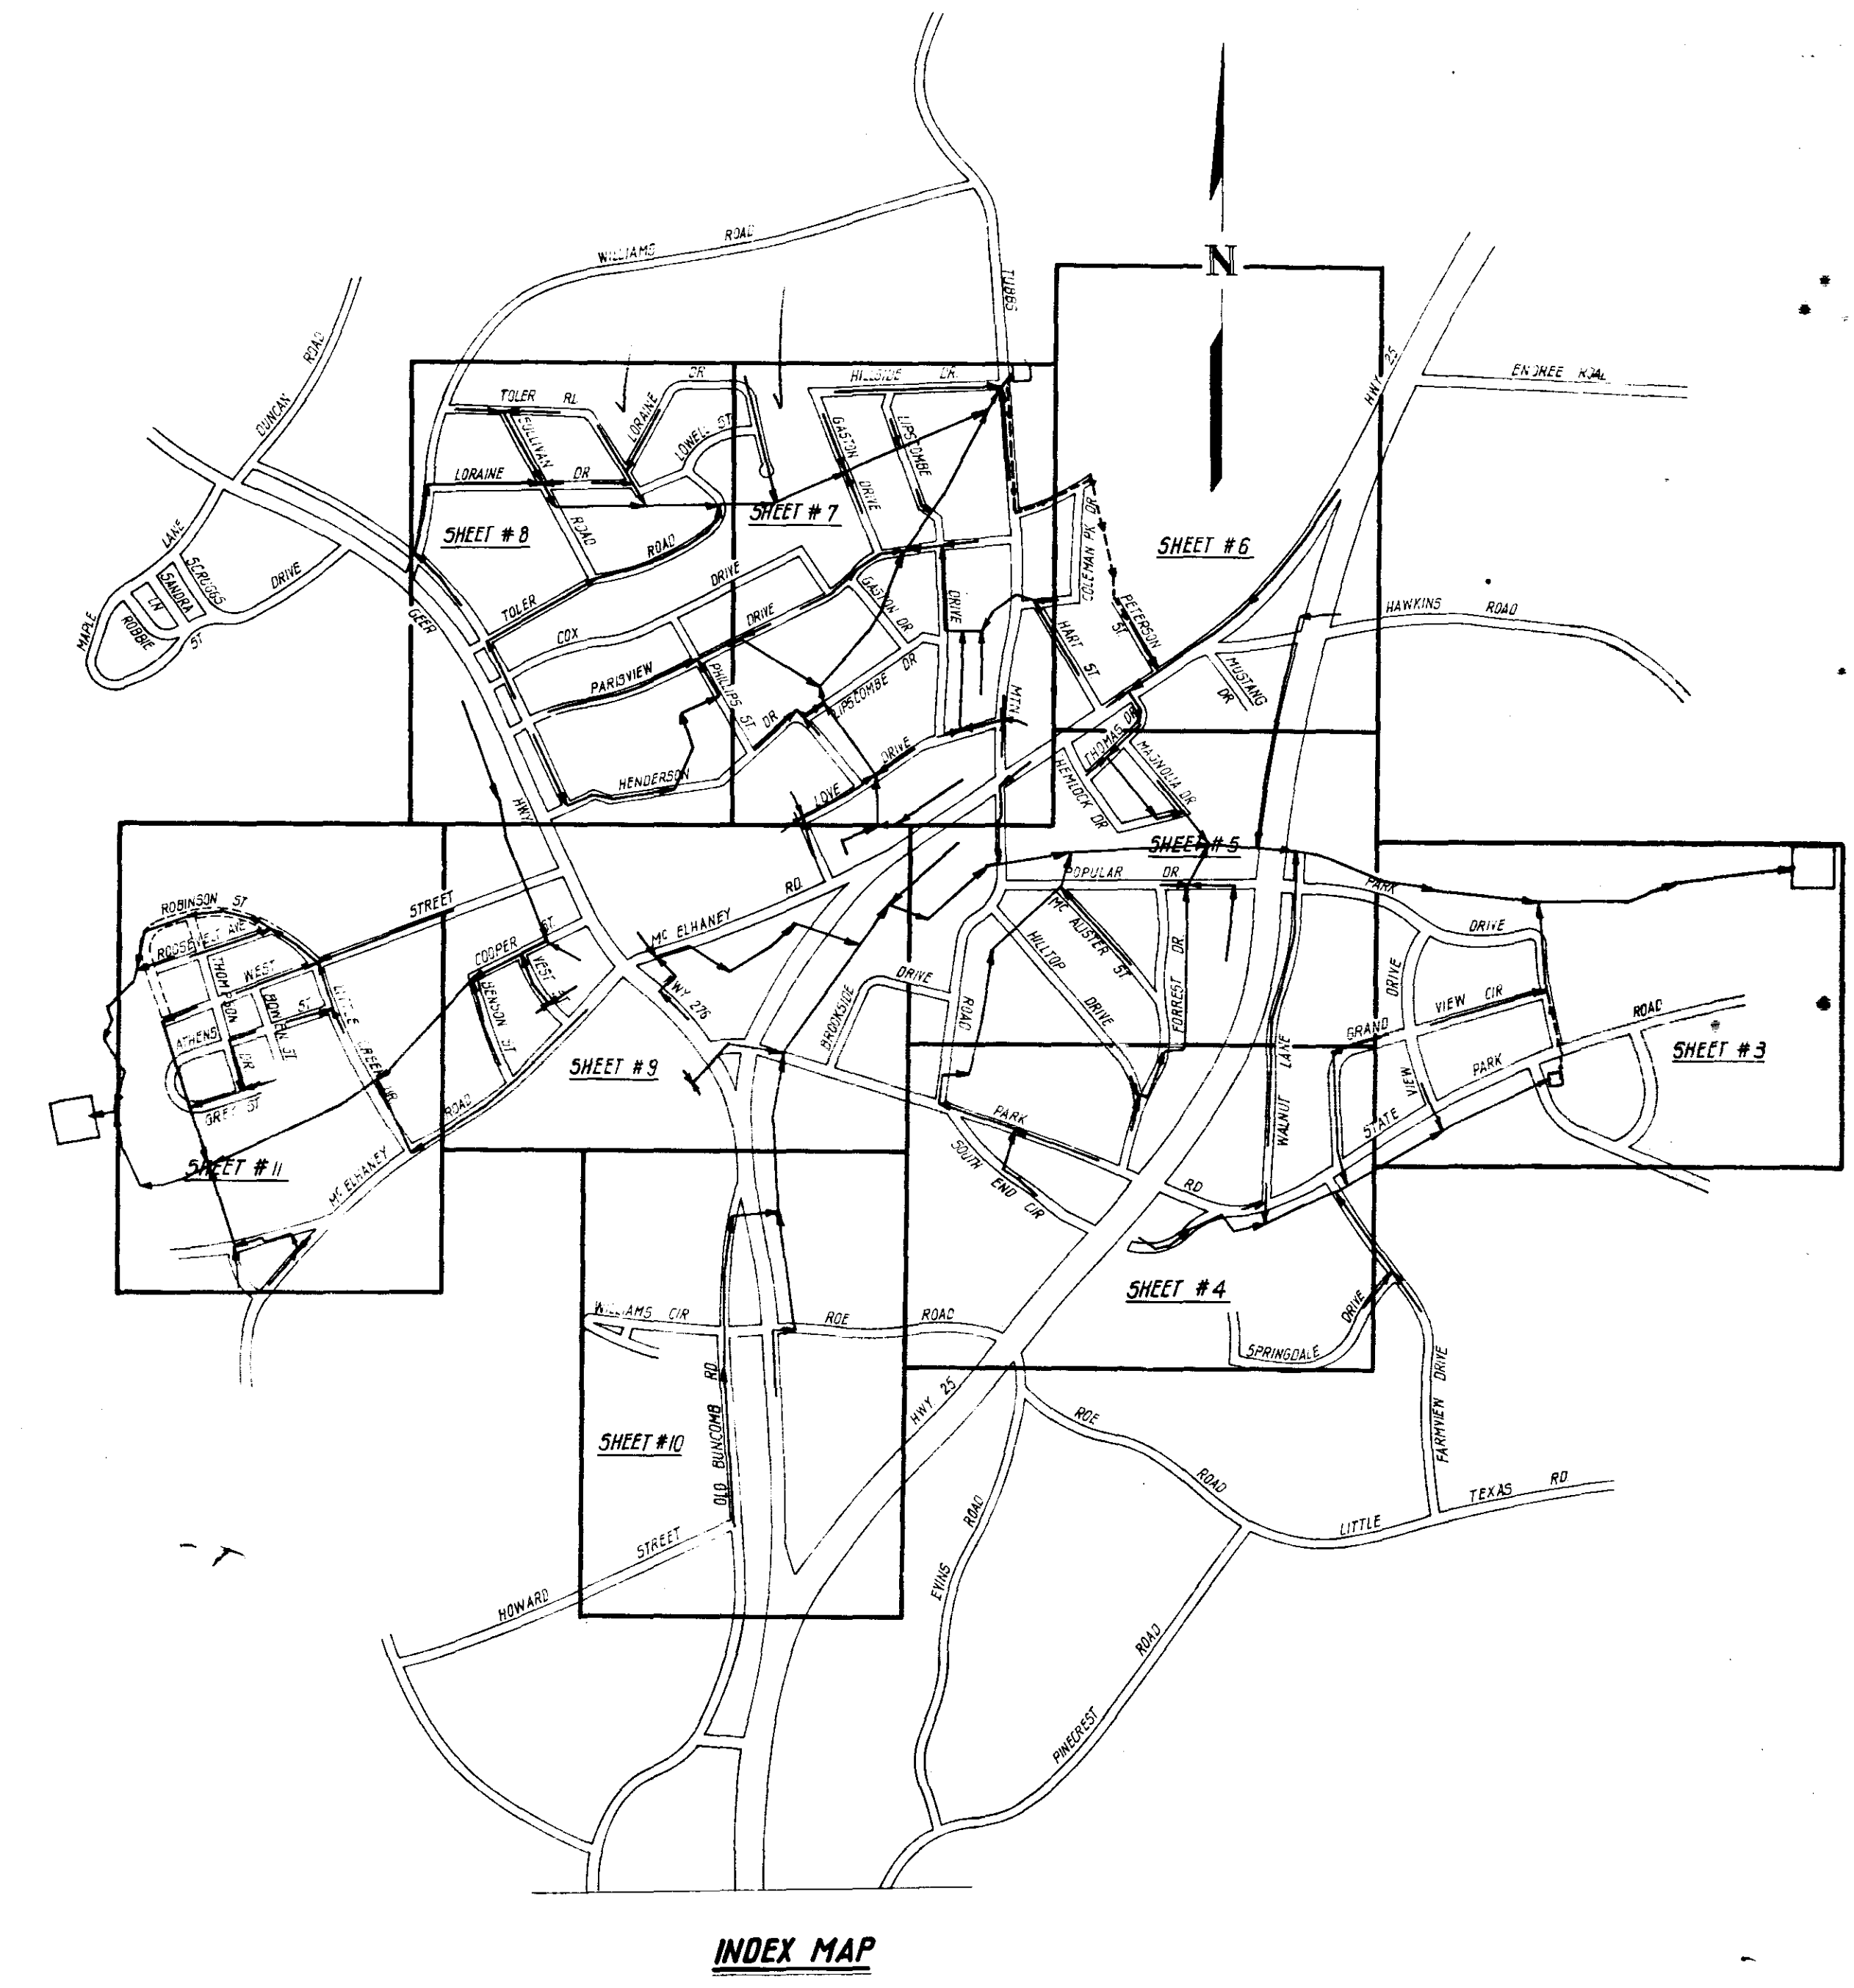

BOOK 4 V PAGE 61

PRINTED
DEC 1 1970

DAVIS AND FLOYD ENGINEERS, INC. CONSULTING ENGINEERS GREENWOOD, S. C. ATLANTA, GA.	OWNER TOWN OF TRAVELERS REST, S.C.	TITLE INDEX MAP	DESIGNED: P.R.F.	SCALE:	CONTRACT NO. 294
			DRAWN: G.F.	DATE: JULY 1968	SH. 2 OF 43
			CHECKED:	BY:	
			APPROVED:	REVISIONS:	