



PLAN

- NOTES**
1. CONTRACTOR FOR DIV. IV IS TO PROVIDE FILL AS SHOWN IN SECTION A-A FROM 13+71-27+85
  2. CONTRACTOR FOR DIV. IV IS TO PLACE SWALE DITCH 15\" RCP AS DIRECTED BY R.E.
  3. SEE SPECIFICATIONS FOR ADDITIONAL EARTH WORK REQUIREMENTS.

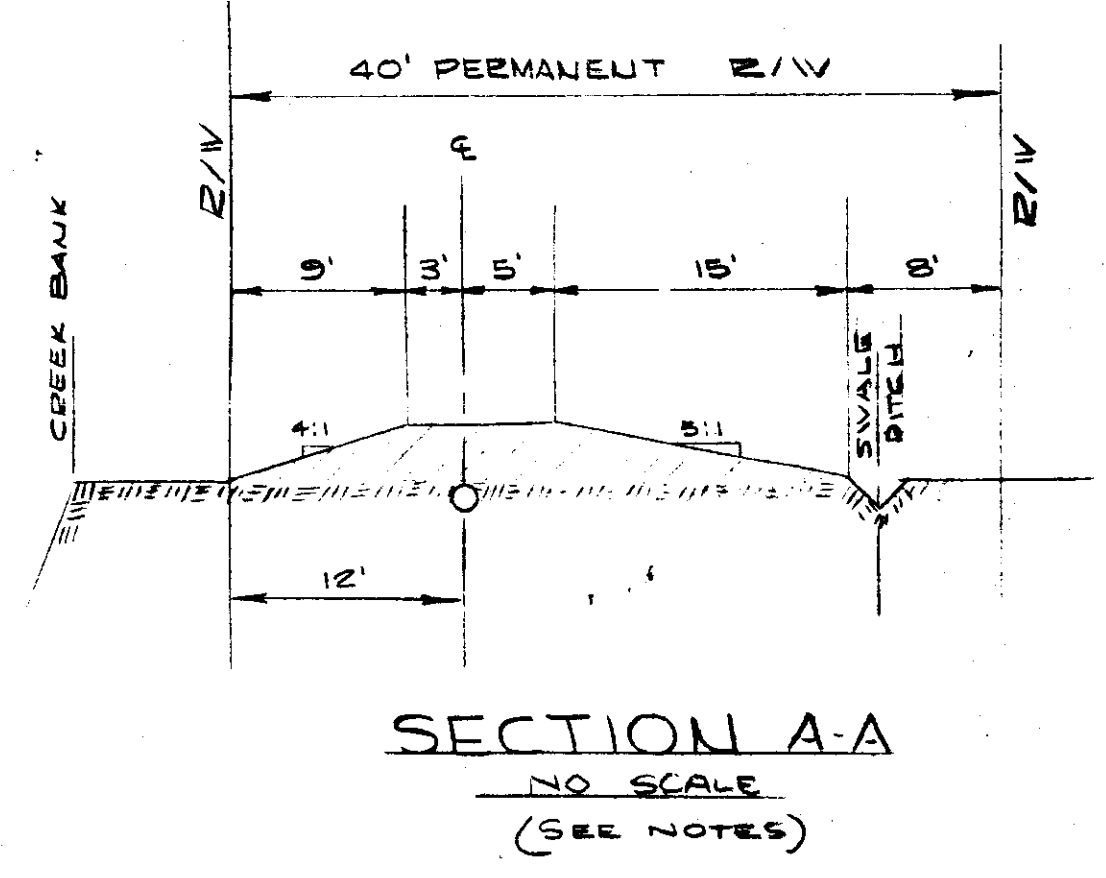


SECTION A-A  
NO SCALE  
(SEE NOTES)

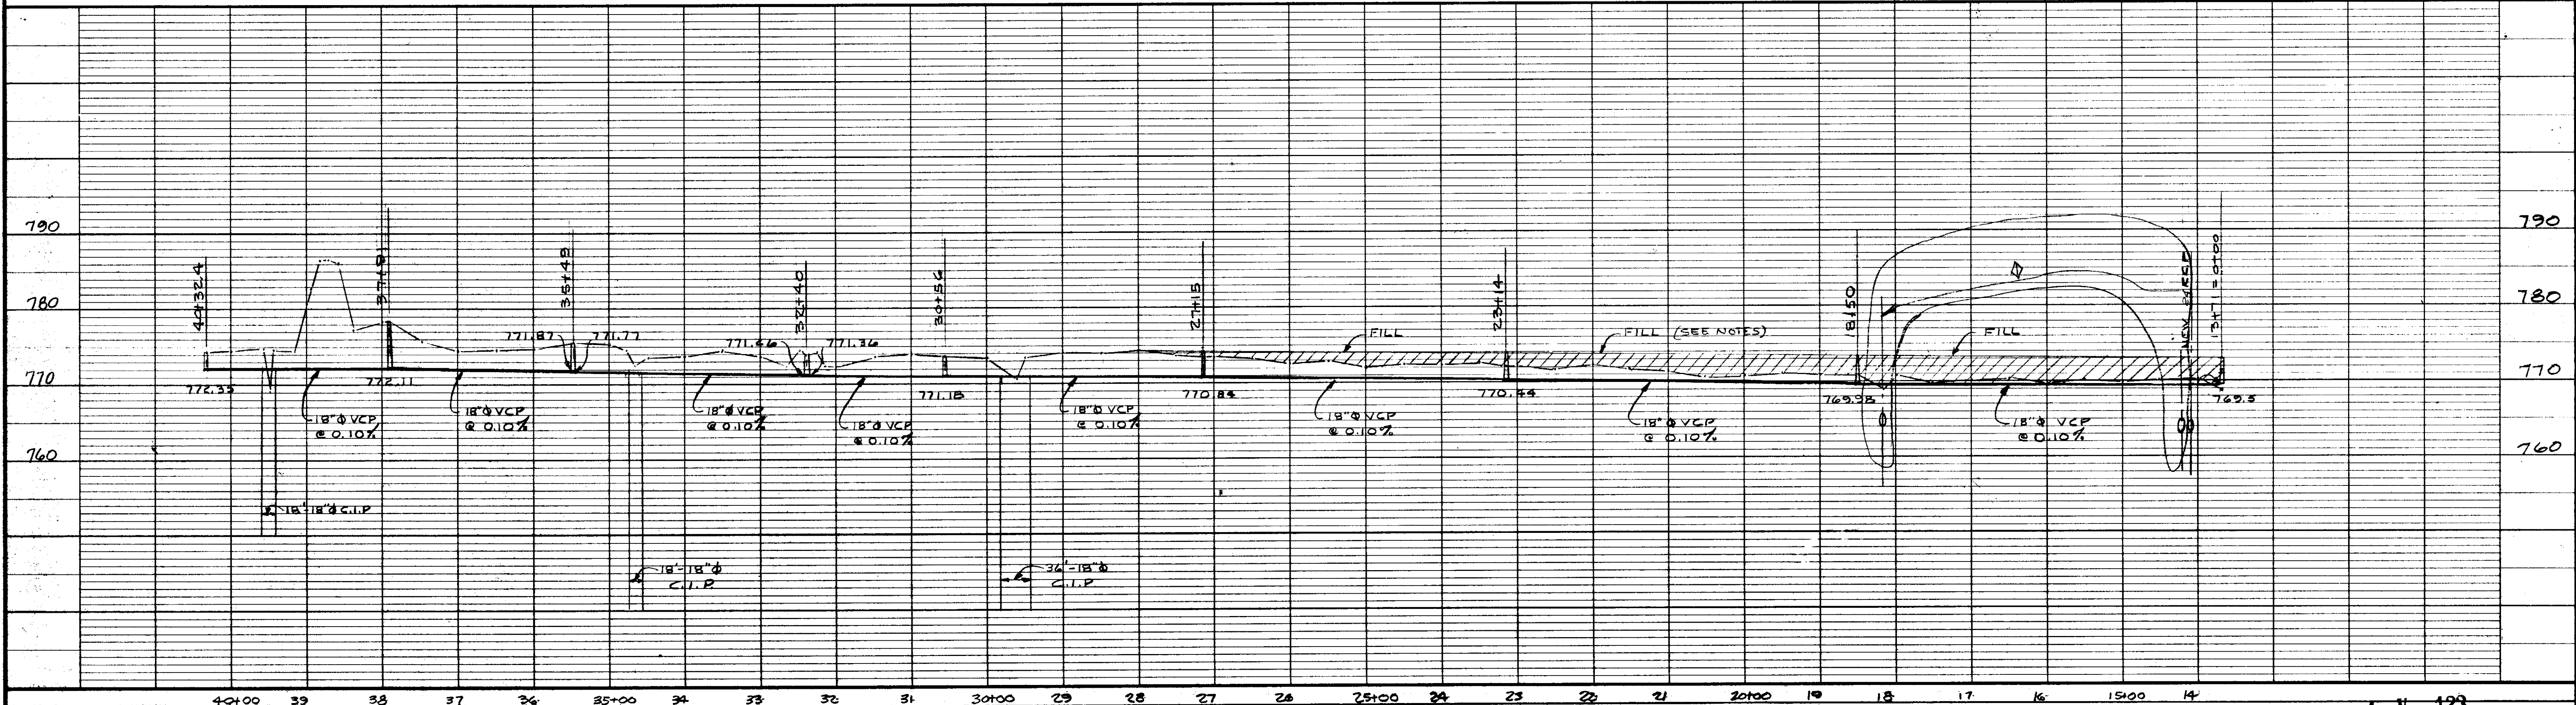

PROFILE


NO.	DATE	BY	REVISIONS DESCRIPTION
1	7-11-66	PEJ	ADDED 24\" RCP

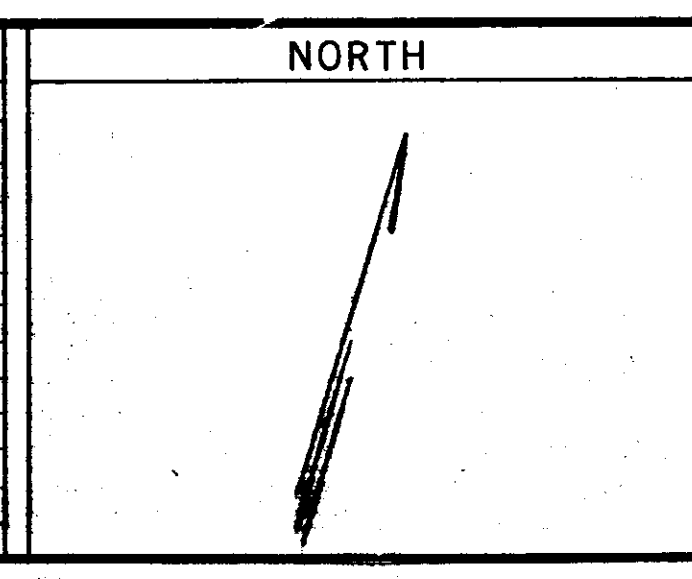

**SCALE**

HORIZONTALLY  
1" = 100'

VERTICALLY  
1" = 10'

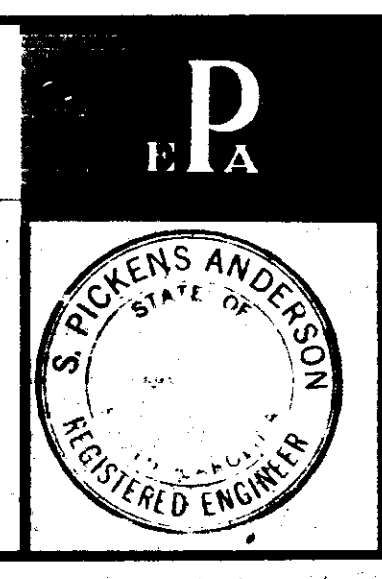

**TOWN OF MAULDIN**  
GREENVILLE COUNTY, S.C.  
**GILDER CREEK BASIN**  
SANITARY SEWERS

**PLAN AND PROFILE**  
INTERCEPTOR SYSTEM

**PIEDMONT**  
ENGINEERS & ARCHITECTS  
420 PARK AVE., GREENVILLE, S.C.

BOOK 4 PAGE 123

LINE G

SHEET NO.  
**27**

DWN R.L.C.  
CKD P.E.D.  
APPD  
JOB 20020  
DATE 4-24-67