


BOOK 4 V PAGE 135  
LINES 6-5; 6-12


REVISIONS	
NO.	DATE BY DESCRIPTION
1	7-24-07/ERC REVISED LINE 6-5 STA. 50+32 TO STA. 66+96.4
2	5/24/08/ERC REVISED LINE 6-5 STA 62+79 TO 64+60.4
3	7/11/08/ERC REVISED LINE 6-6 STA 62+79 TO 64+60.4

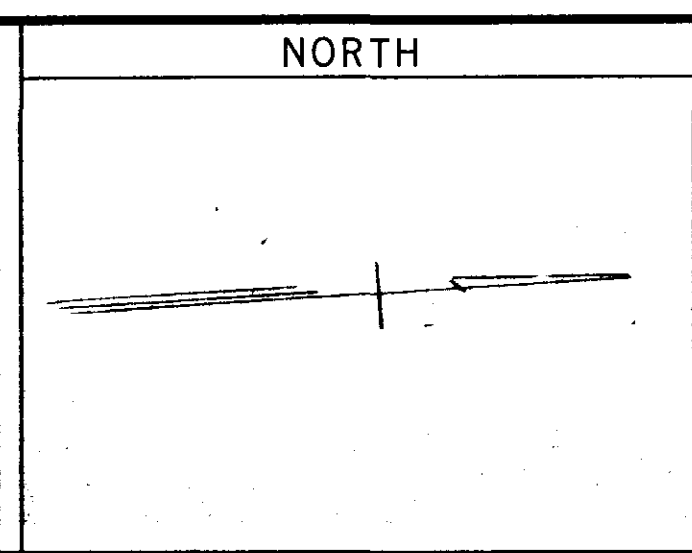

SCALE

HORIZONTALLY  
1" = 100'

VERTICALLY  
1" = 10'

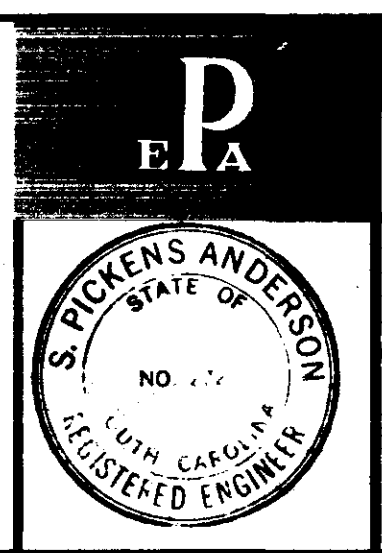

TOWN OF MAULDIN  
GREENVILLE COUNTY, S.C.  
**GILDER CREEK BASIN**  
SANITARY SEWERS

**PLAN AND PROFILE**  
INTERCEPTOR SYSTEM

PIEDMONT  
ENGINEERS & ARCHITECTS  
420 PARK AVE., GREENVILLE, S.C.

SHEET NO.  
**39**

DWN R.L.C.  
CKD P.E.D.  
APPD  
JOB 20020  
DATE 4-24-67