



NOTE:
 1. CONNECTION TO BE LOCATED IN LINE BY PROPERTY OWNER.
 2. SERVICE LINE TO BE LOCATED BY OWNER

PLAN

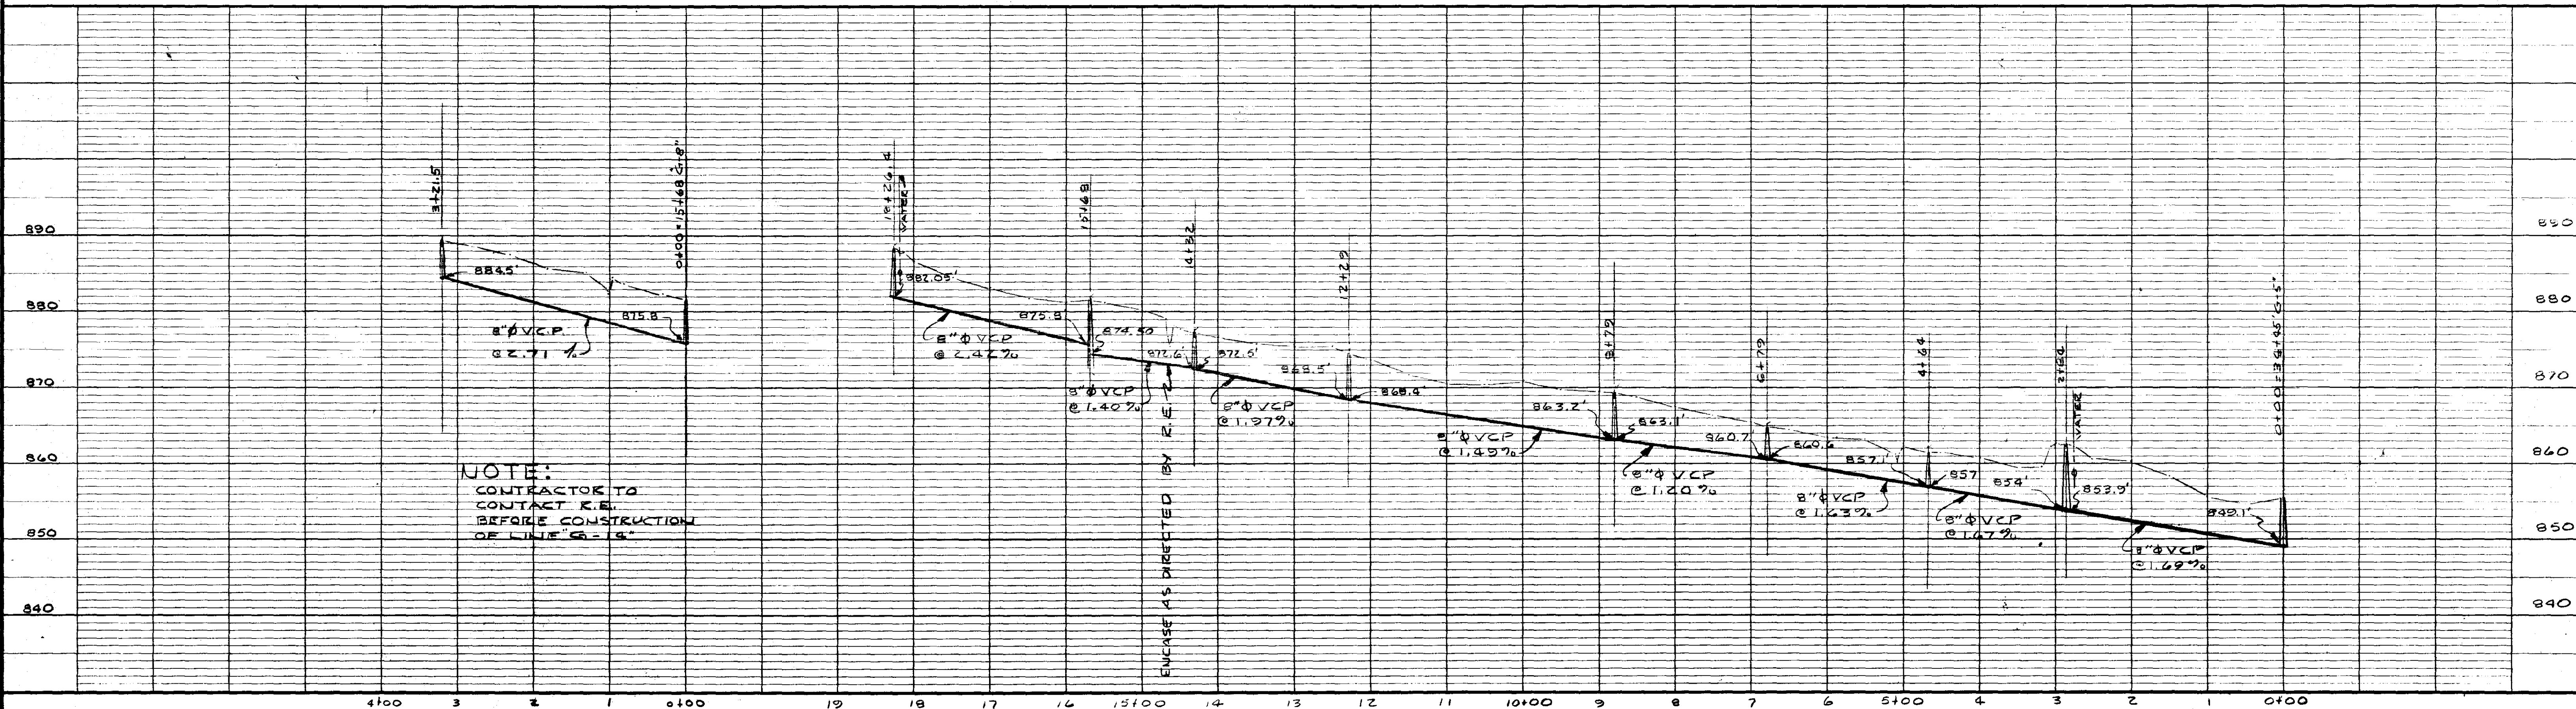


PROFILE

NO.	DATE	BY	DESCRIPTION
1	9/11/20	RJC	ADDED LINE FROM D-14

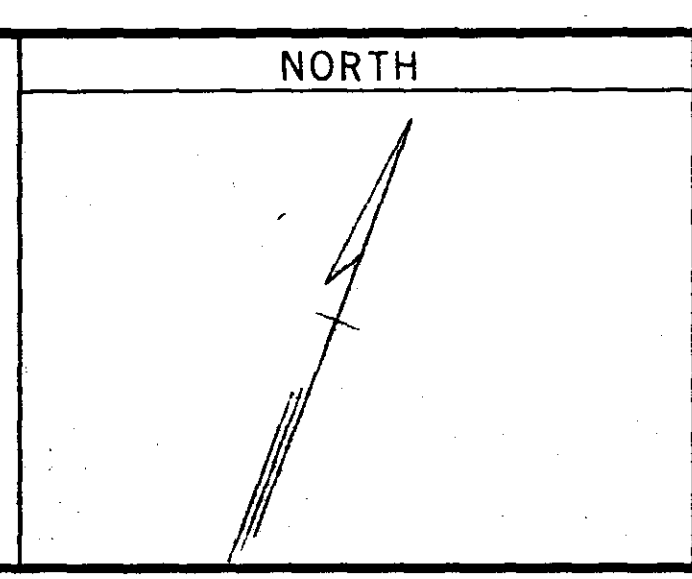

SCALE
 HORIZONTALLY
 1" = 100'
 VERTICALLY
 1" = 10'

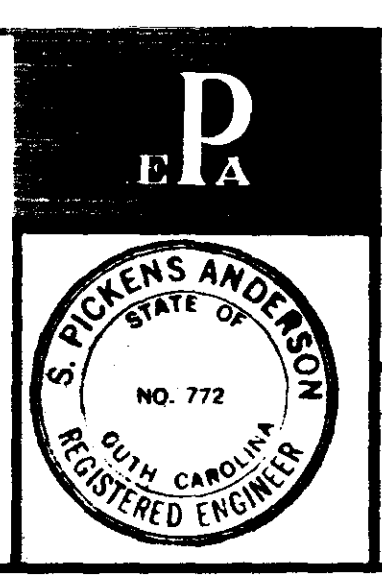

PROJ. NO. WS-3-41-011
 TOWN OF MAULDIN
 GREENVILLE COUNTY, S.C.
 GILDER CREEK BASIN
 SANITARY SEWERS
 PLAN AND PROFILE
 INTERCEPTOR SYSTEM
 PIEDMONT
 ENGINEERS & ARCHITECTS
 420 PARK AVE., GREENVILLE, S.C.

SHEET NO. 41
 DWN R.L.C.
 CKD P.E.D.
 APPD
 JOB 20020
 DATE 4-24-67