

MICROFILMED

100-1


6670 --- 1 AUG 17 78 223

GREENVILLE CO. S. C.

AUG 17 4 21 PM '78  
DONNIE S. TANKERSLEY  
R.M.C.

5328

AUG 17 1978

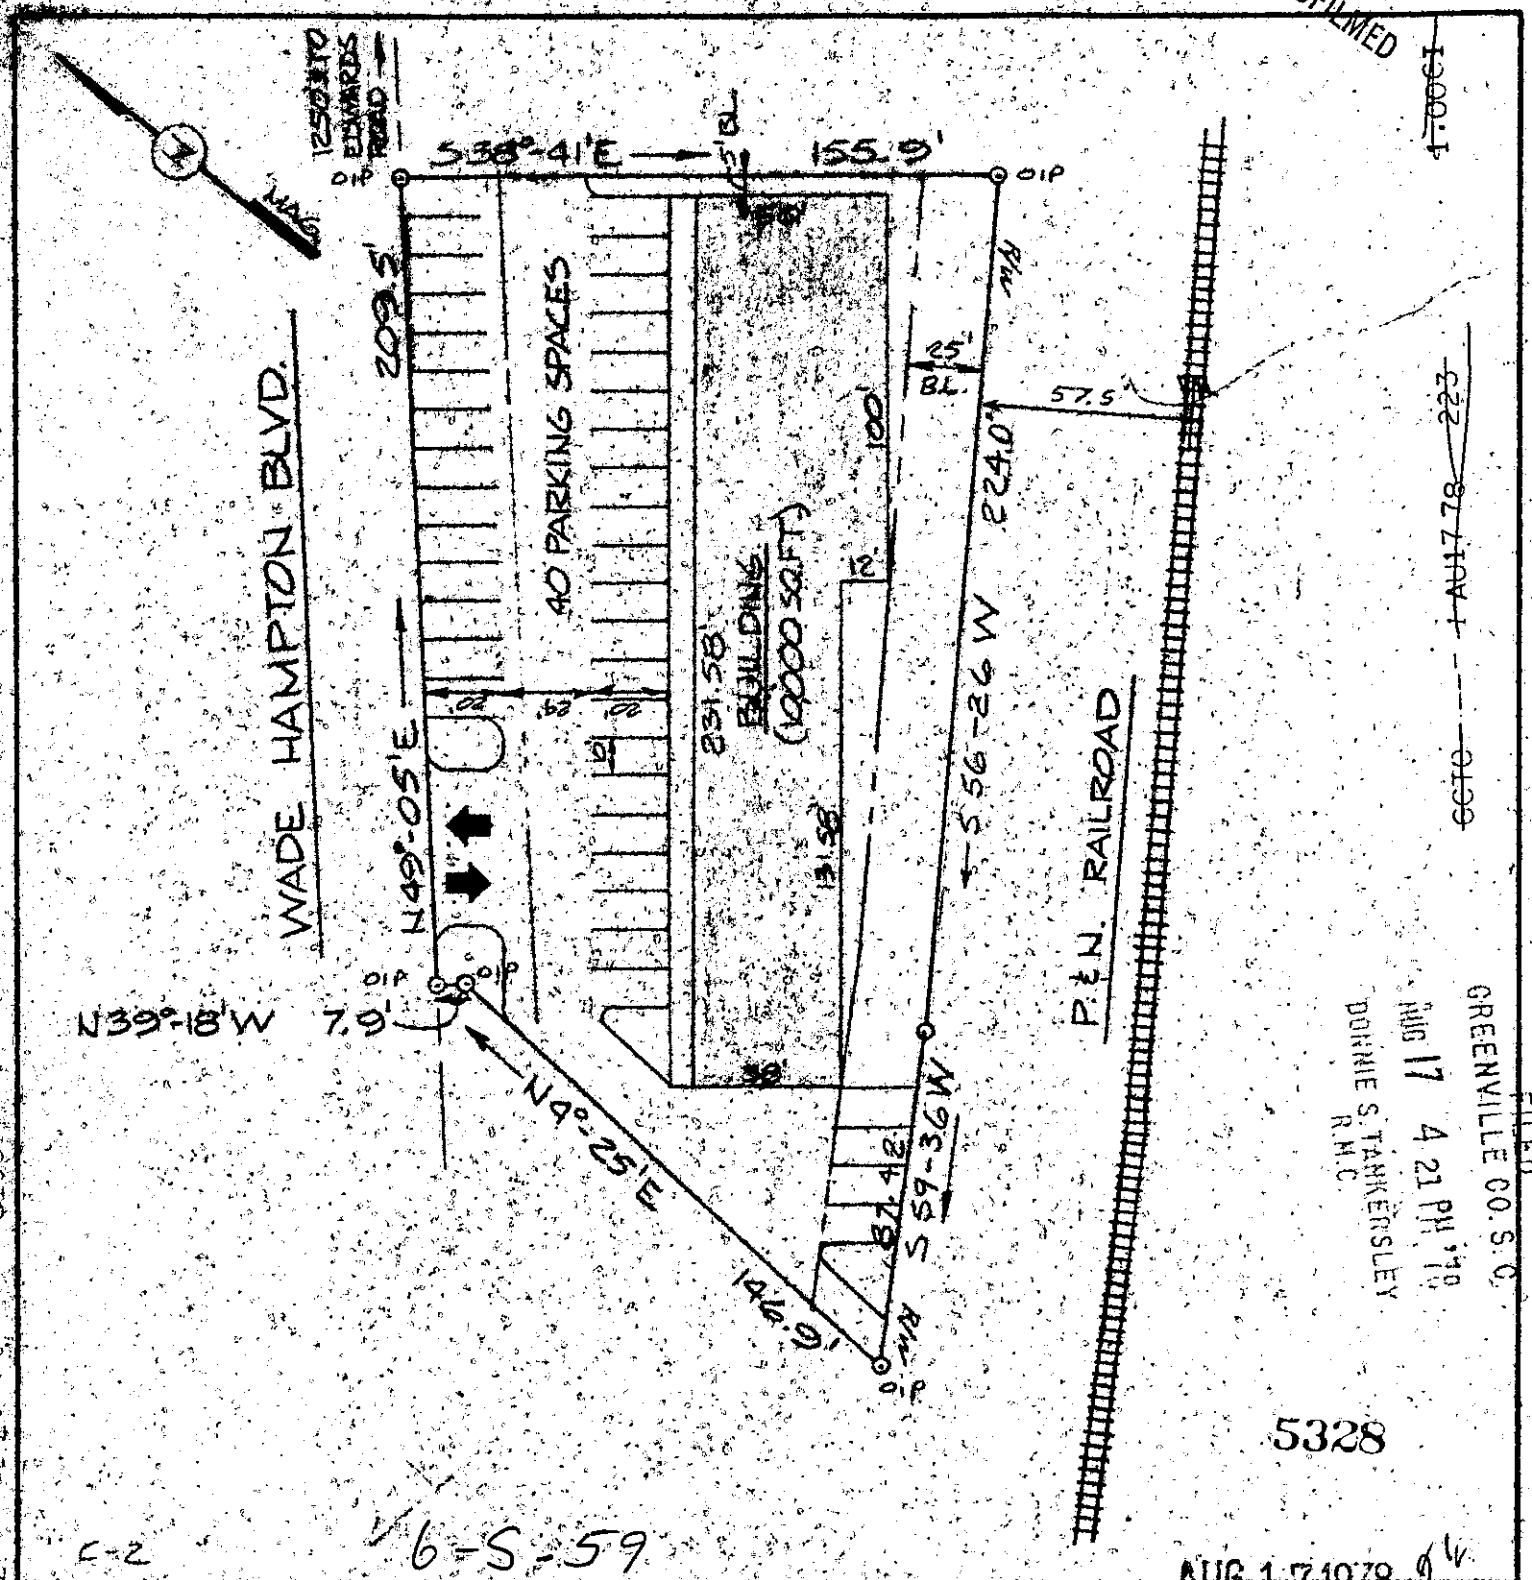

6670 --- 1 AUG 17 78 1132



SEAL

**STATE OF SOUTH CAROLINA  
GREENVILLE COUNTY**

**PROPOSED SITE PLAN FOR  
ROBERT D GARRETT**

**FREELAND & ASSOCIATES**  
Engineers • Land Surveyors

GREENVILLE, S. C.

SURVEY	UBHE
DRAWN	DL
CHECK	UBHE
SCALE	1" = 50'
DATE	7-27-78
DWG. NO.	78-2280